

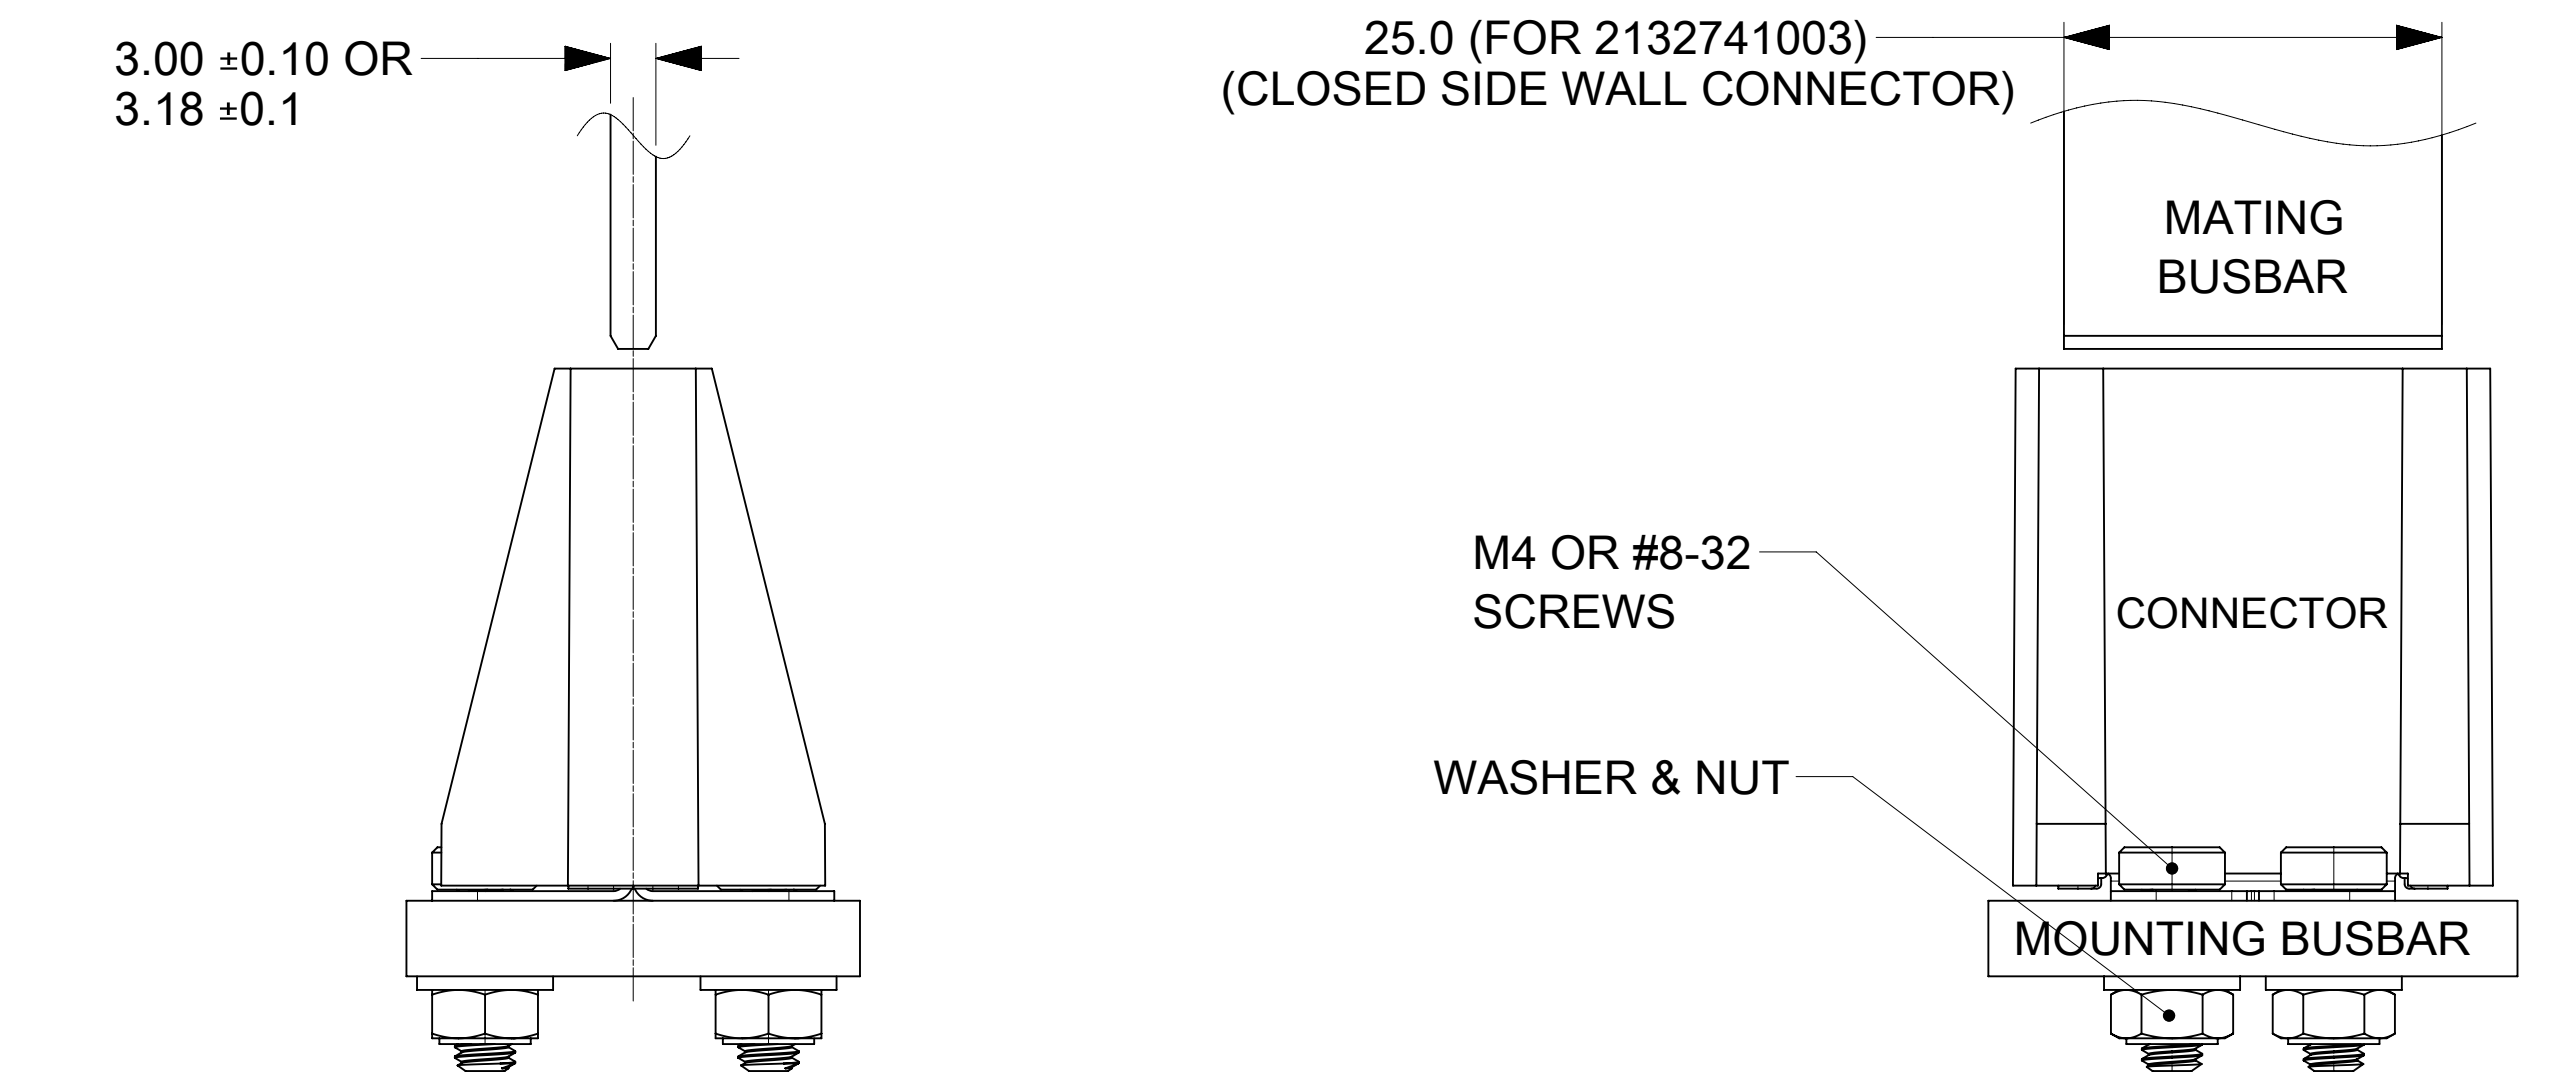


PART NUMBER	DESCRIPTION	NOTE
2132740003	OPEN SIDE WALL	
2132741003	CLOSED SIDE WALL	

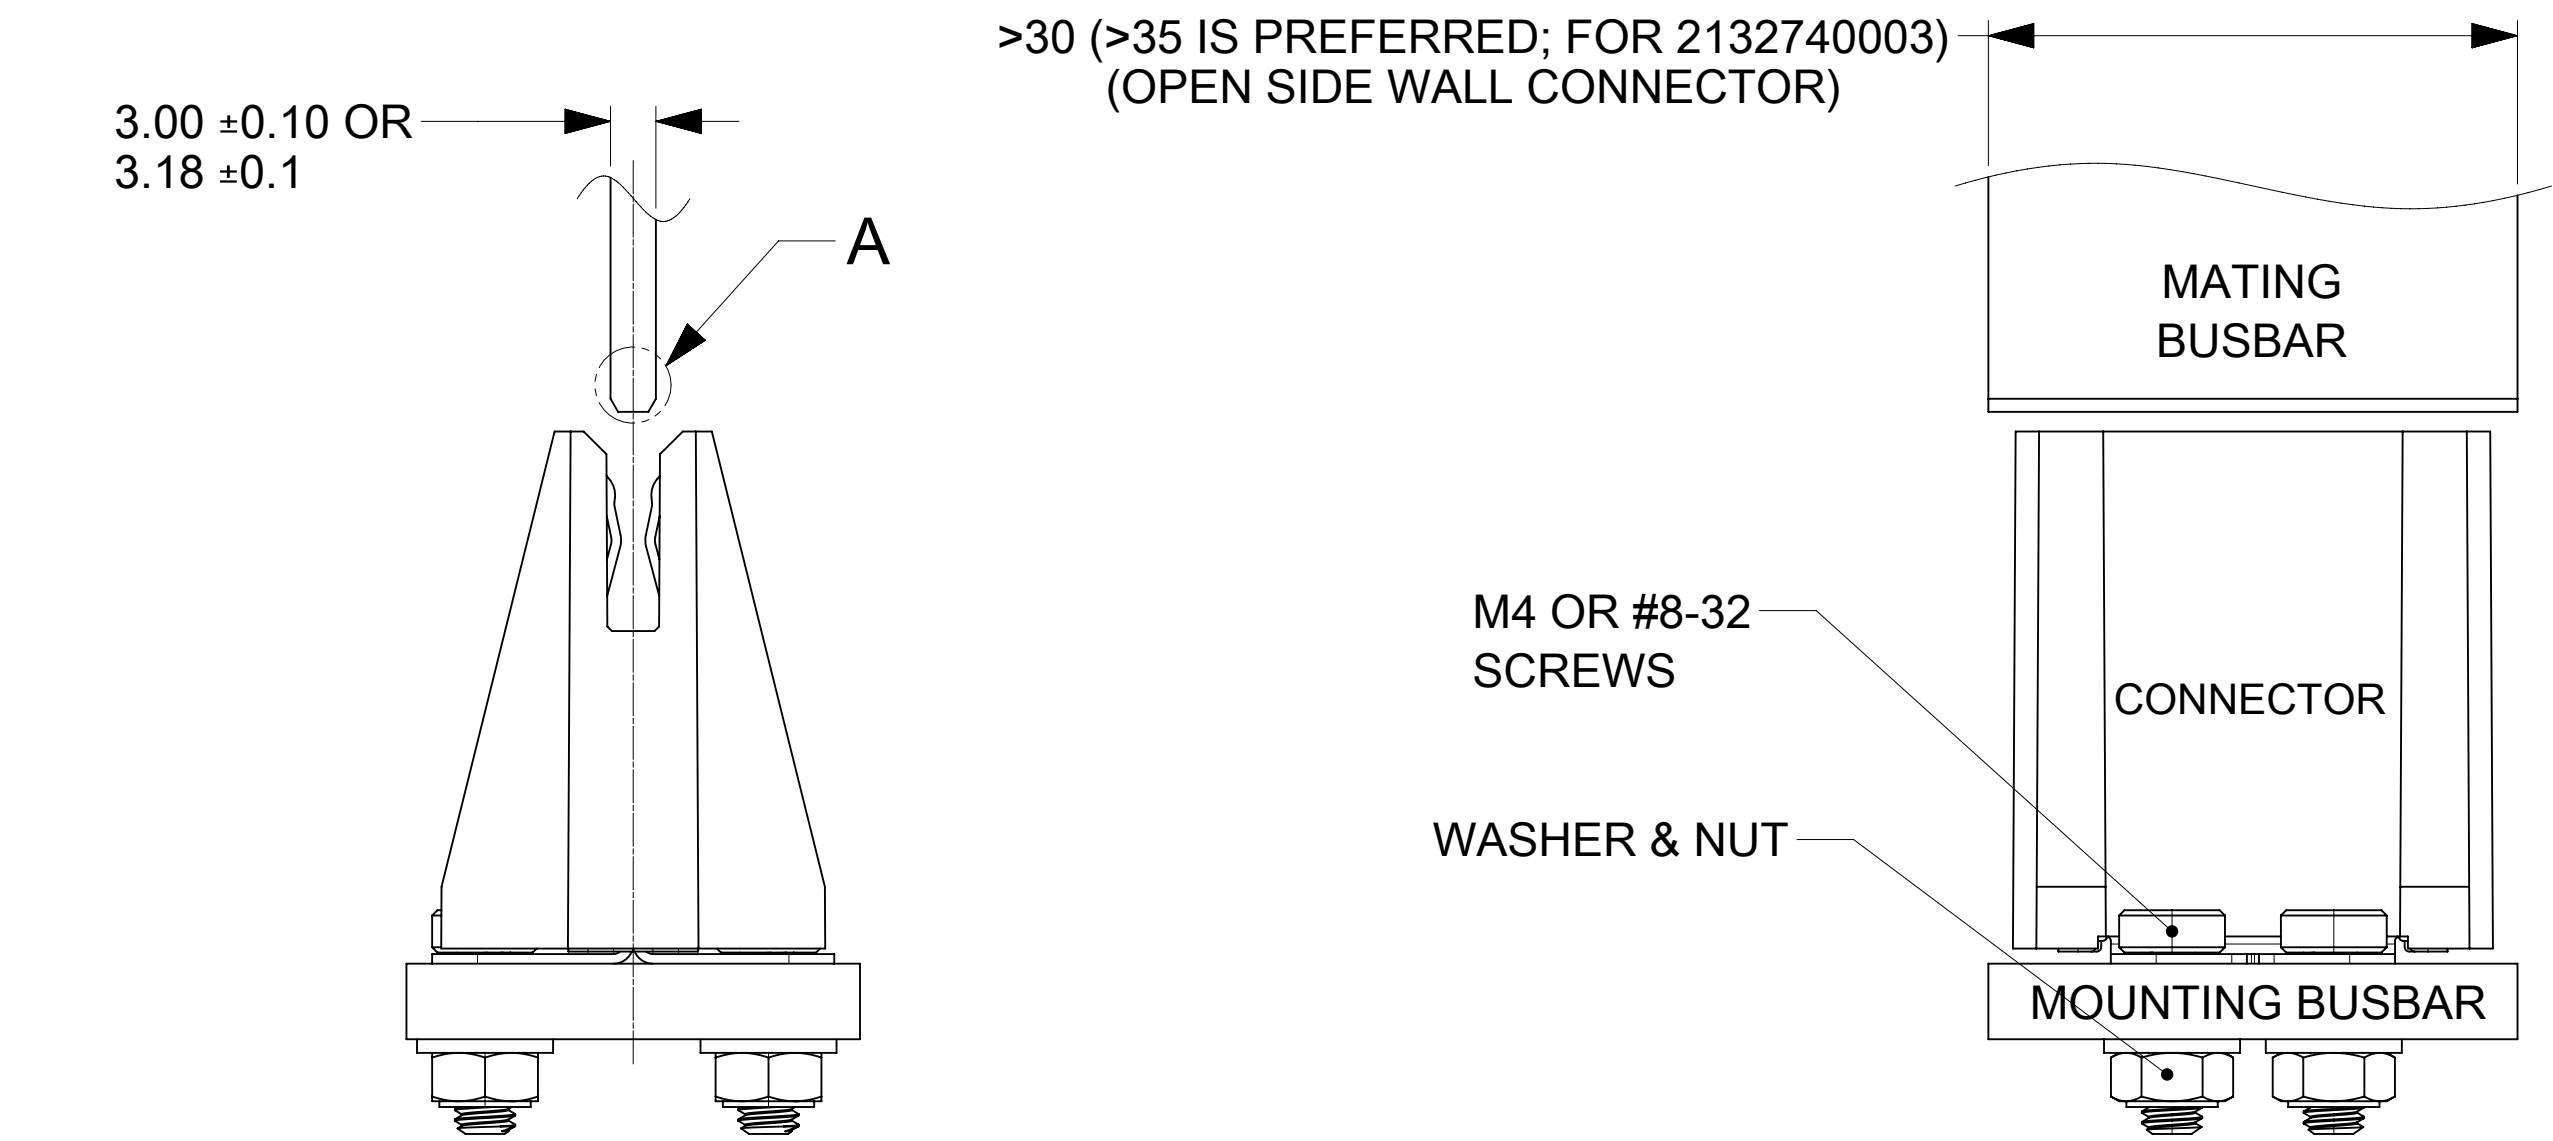



BUSBARS, SCREWS, WASHER AND NUTS
IN THESE VIEWS ARE SHOWN FOR REFERENCE

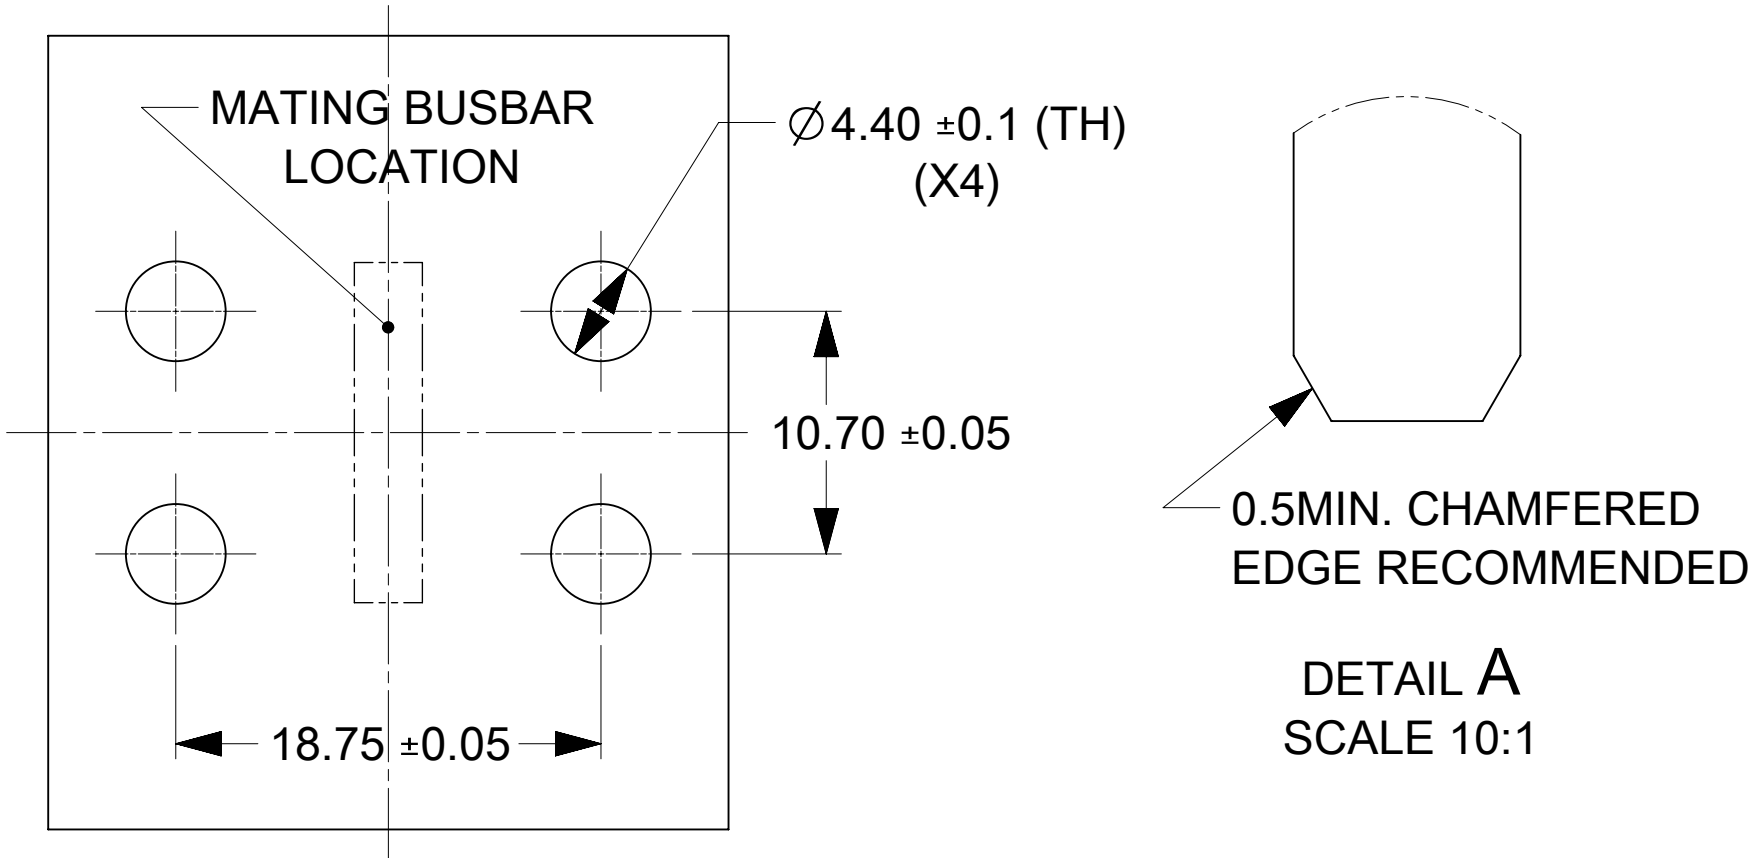



RECOMMENDED BUSBAR LAYOUT

DOCUMENT STATUS	P1	RELEASE DATE	2022/01/07	20:21:56
-----------------	----	--------------	------------	----------

- NOTES:
- MATERIALS:
 - HOUSING BODY: POLYMER, UL94V-0, BLACK.
 - TERMINALS: COPPER ALLOY.
 - RIVET/CLIP: COPPER ALLOY.
 - PLATING:
 - CONTACT AREAS: 3.18 MICRON MIN. SILVER, OVER 1.27 MICRON MIN. NICKEL.
 - TAB AREAS: 3.18 MICRON MIN. TIN OVER 1.27 MICRON MIN. NICKEL.
 - REST: 1.27 MICRON MIN. NICKEL.
 - LUBRICATION: LUBED IN CONTACT AREA.
 - REFERENCE DOCUMENT: 2132740001-PS, 2132740001-AS
 - MODULE ASSEMBLY IS RoHS COMPLIANT.
 - FINAL ASSEMBLY TO BE PACKAGED AND LABELED PER PACKAGING KIT DRAWING NUMBER 2132740003-PK.

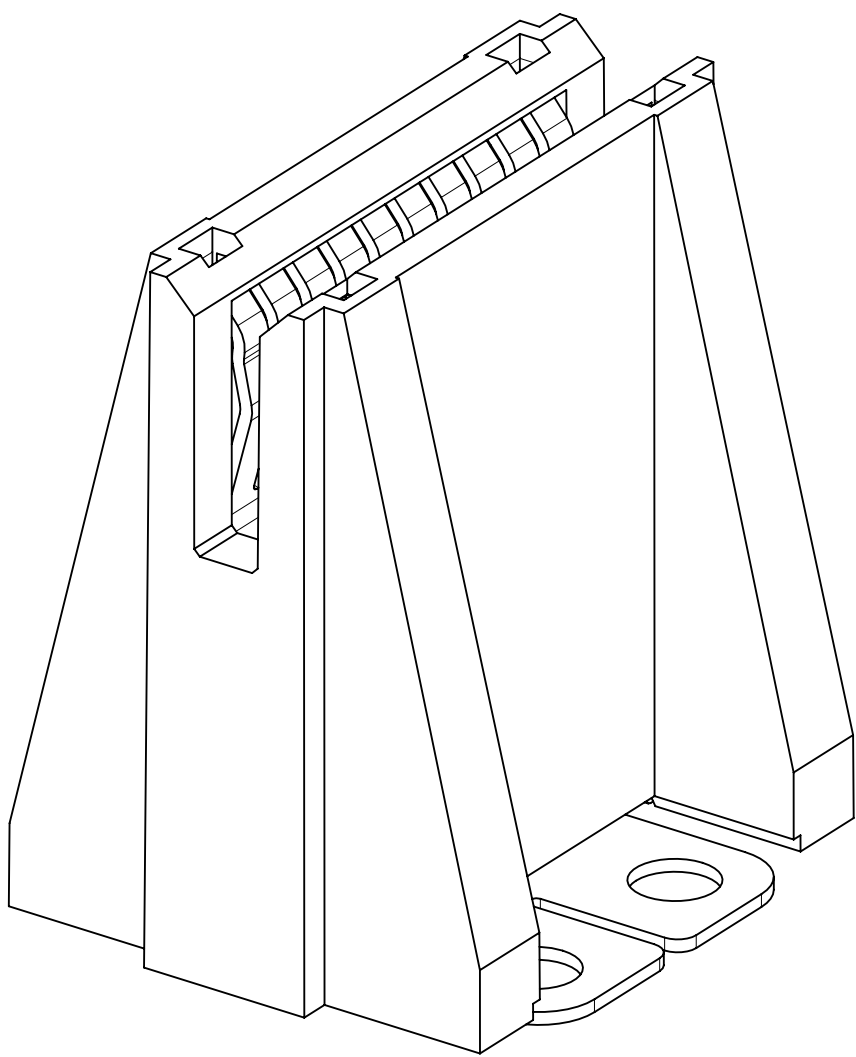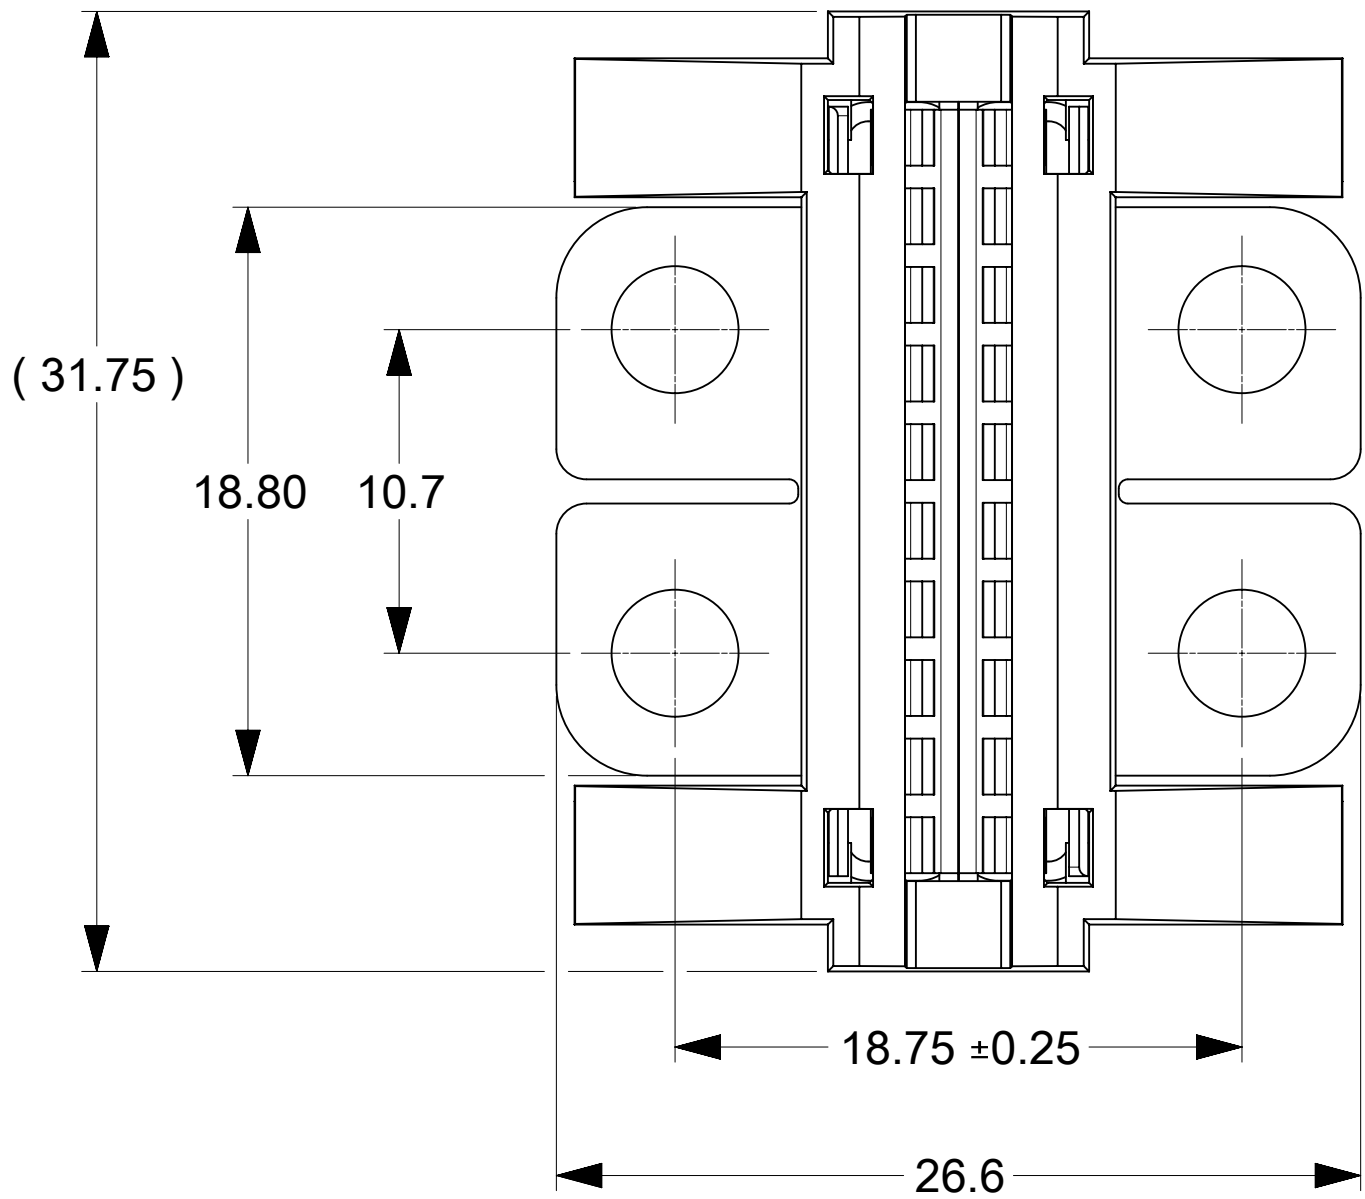

PART NUMBER: 2132740003
(OPEN SIDE WALLS)

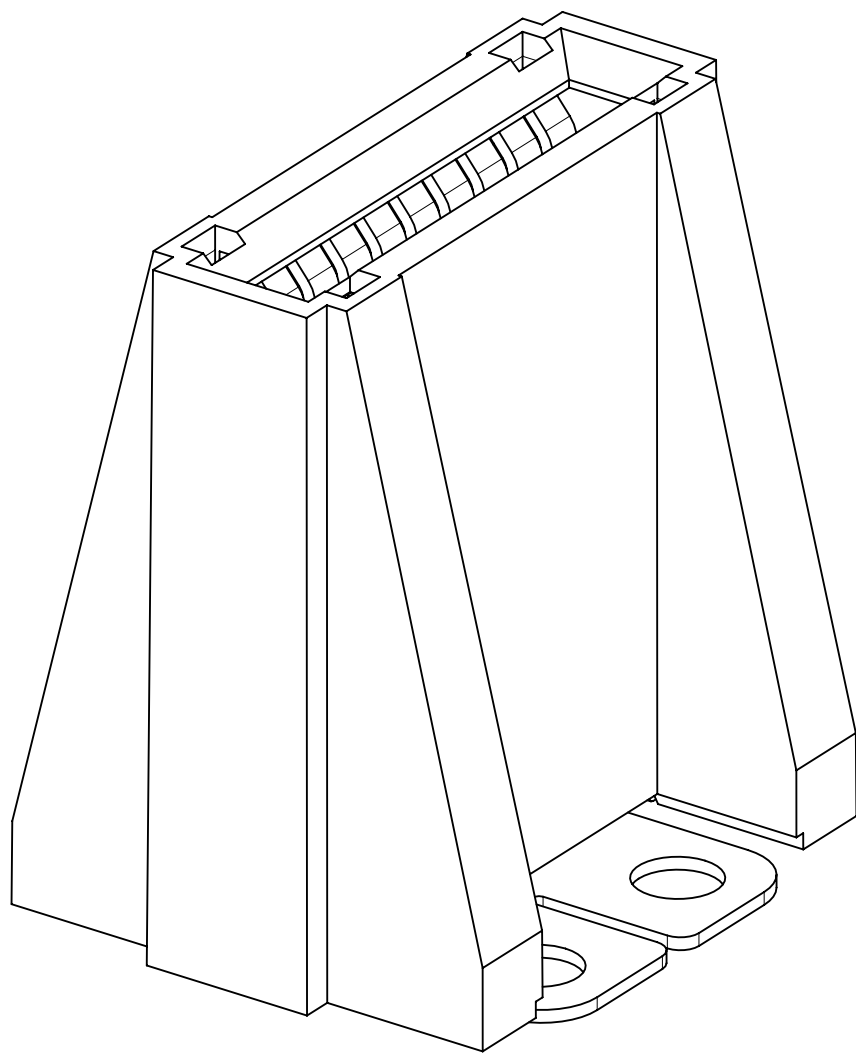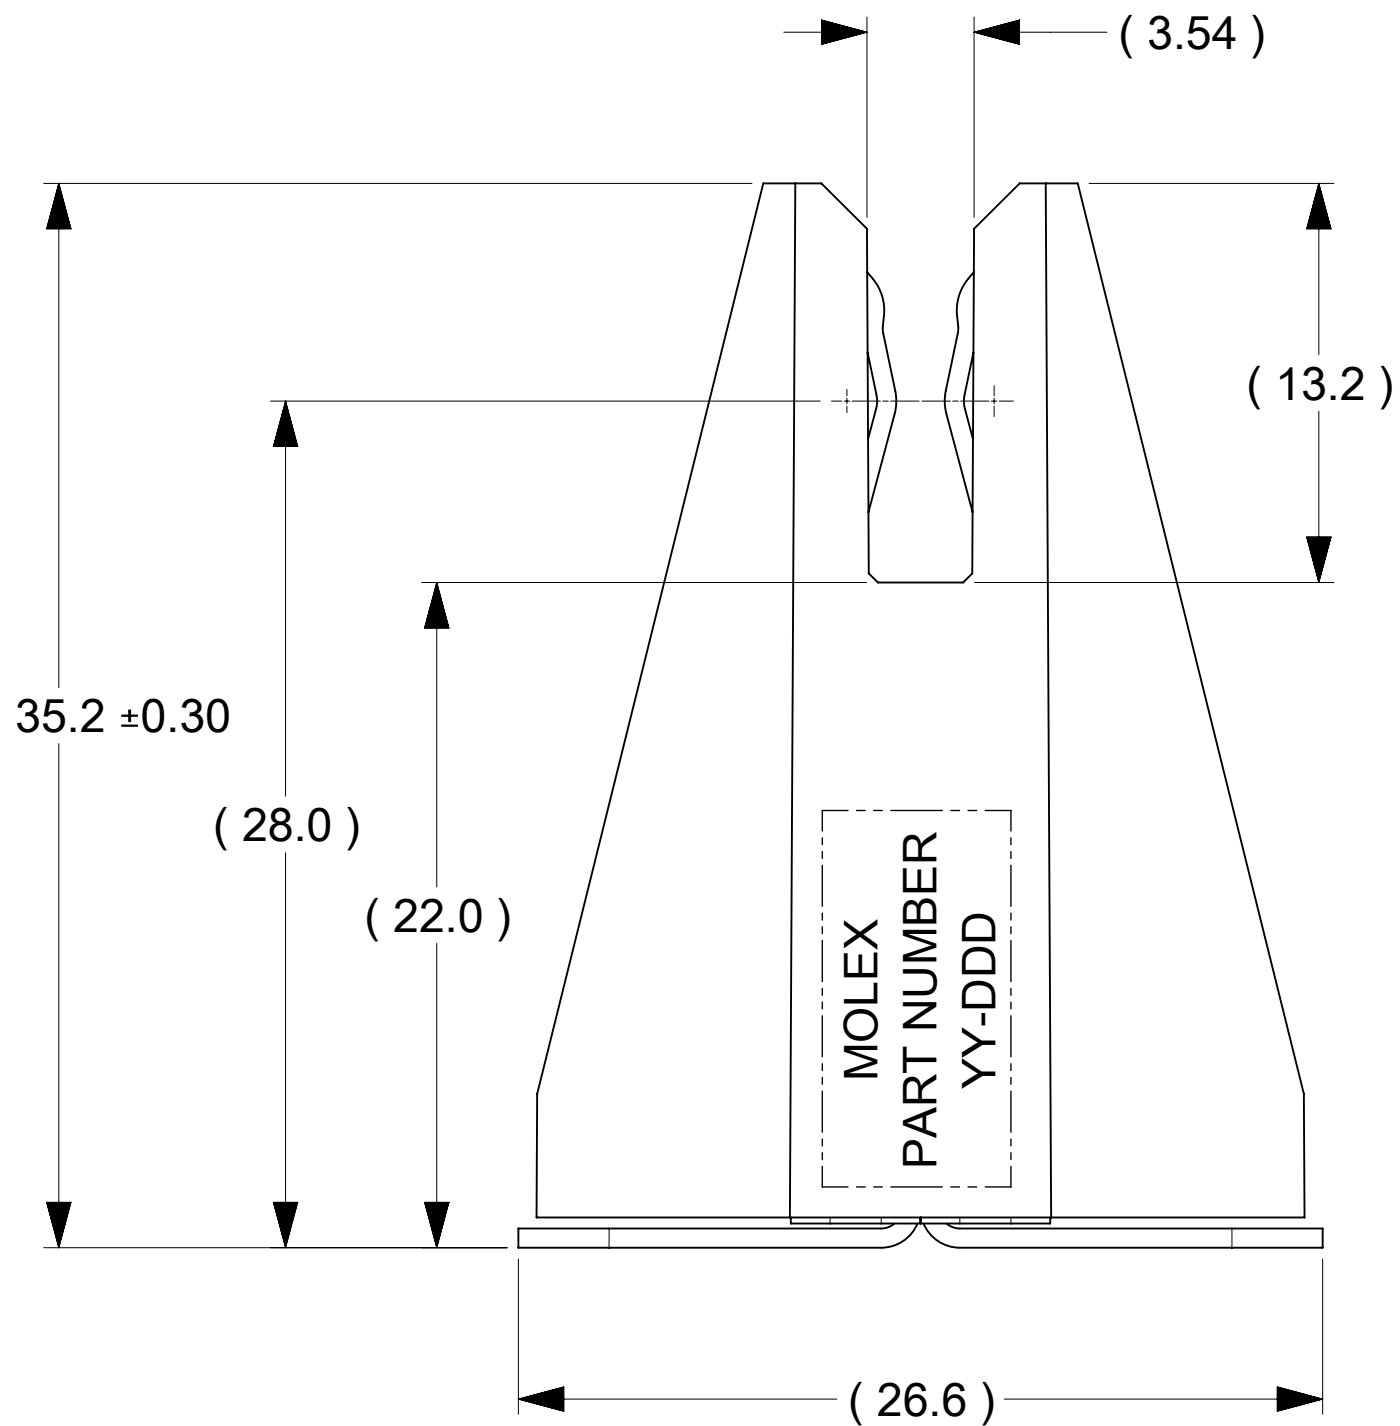

PART NUMBER: 2132741003
(CLOSED SIDE WALLS)

FUNCTIONAL SYMBOLS	THIS DRAWING CONTAINS INFORMATION THAT IS PROPRIETARY TO MOLEX ELECTRONIC TECHNOLOGIES, LLC AND SHOULD NOT BE USED WITHOUT WRITTEN PERMISSION															
DIVISIONAL SYMBOLS	DIMENSION UNITS		SCALE		CURRENT REV DESC:			molex								
	mm		3:1													
	GENERAL TOLERANCES (UNLESS SPECIFIED)					POWER PLANE BBC 10C VERTICAL										
	ANGULAR TOL ± °															
	4 PLACES		±		EC NO: 690682											
	3 PLACES		±		DRWN: TOMLU 2022/01/03											
	2 PLACES		± 0.15		CHK'D: BPISZCZOR 2022/01/04											
	1 PLACE		± 0.25		APPR: BPISZCZOR 2022/01/04											
	0 PLACES		±		INITIAL REVISION:											
DRAFT WHERE APPLICABLE MUST REMAIN WITHIN DIMENSIONS					THIRD ANGLE PROJECTION			DRAWING		SERIES		DOCUMENT NUMBER		DOC TYPE	DOC PART	REVISION
								D-SIZE		213274		2132740003-SD		PSD	000	A1
												MATERIAL NUMBER		CUSTOMER		SHEET NUMBER
										SEE CHART				1 OF 1		