

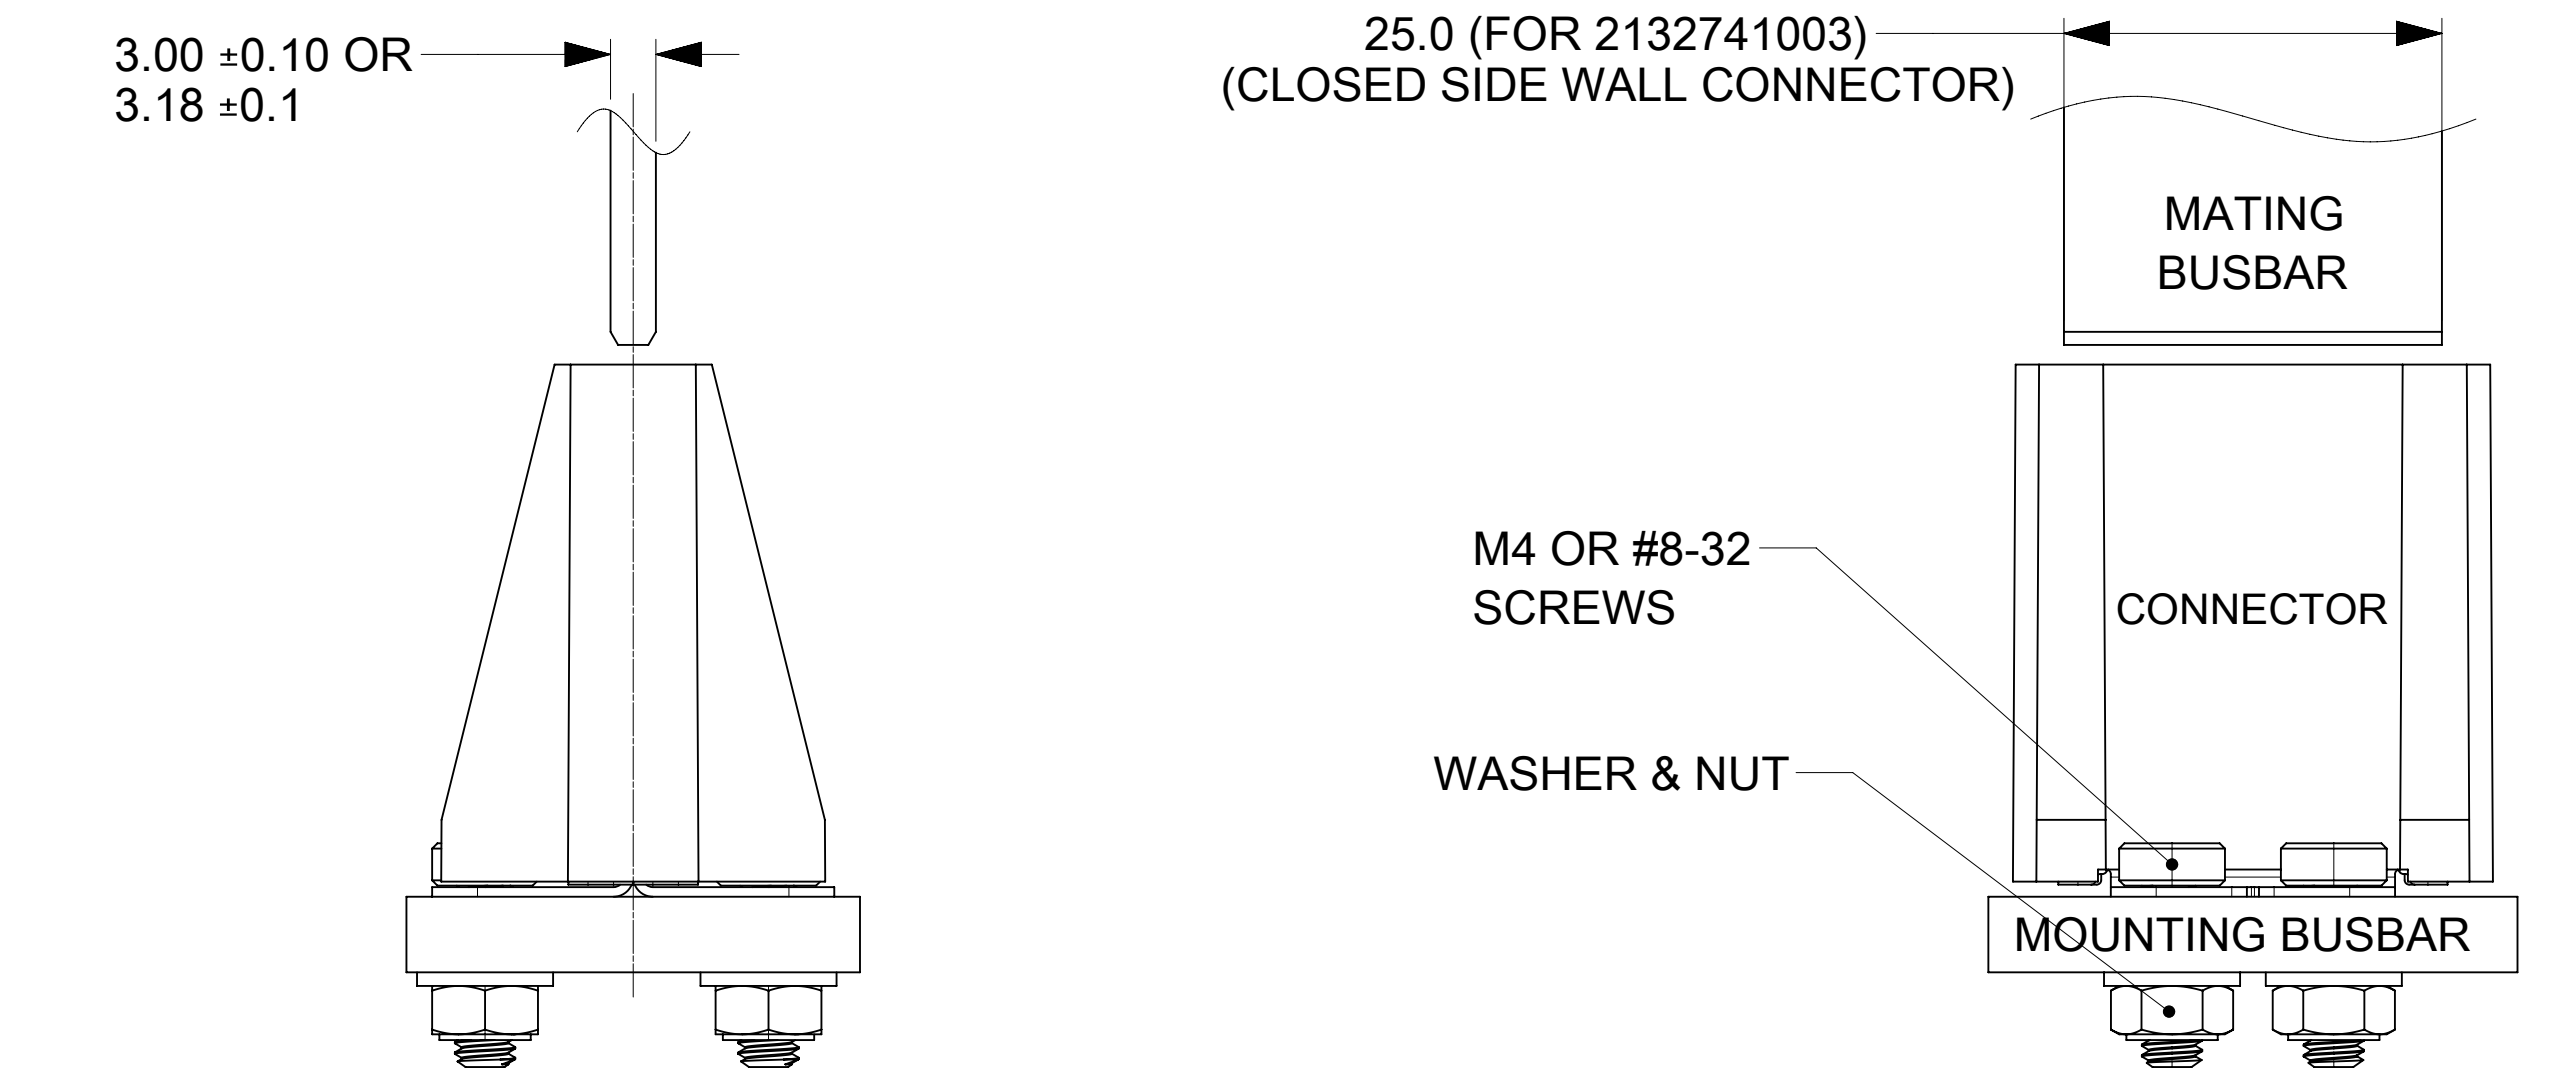


PART NUMBER	DESCRIPTION	NOTE
2132740003	OPEN SIDE WALL	
2132741003	CLOSED SIDE WALL	


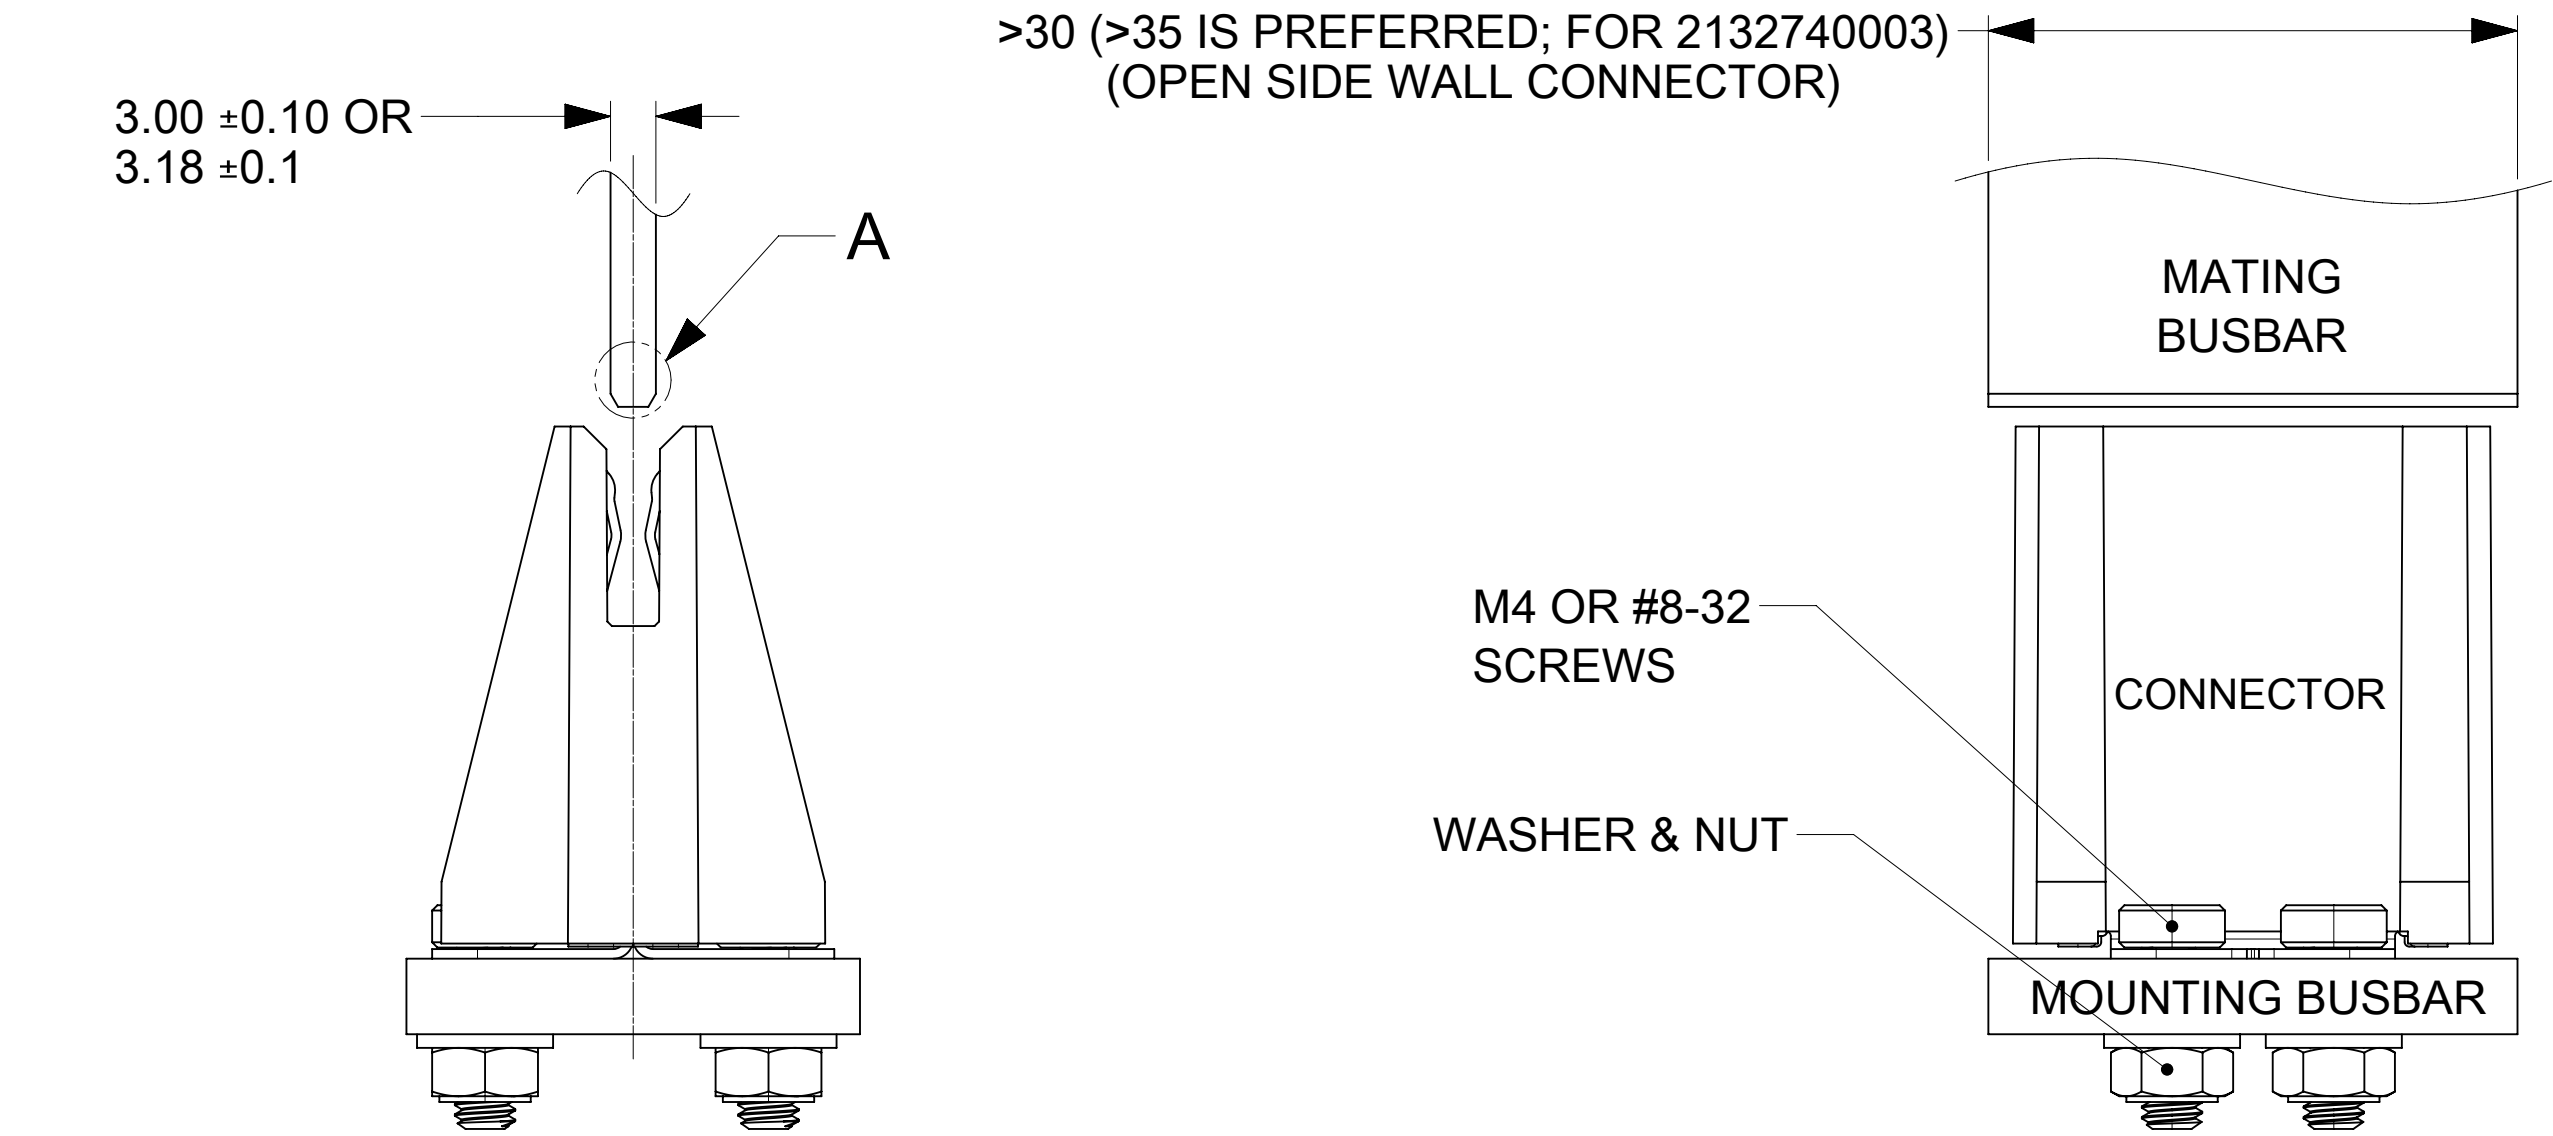


BUSBARS, SCREWS, WASHER AND NUTS
IN THESE VIEWS ARE SHOWN FOR REFERENCE


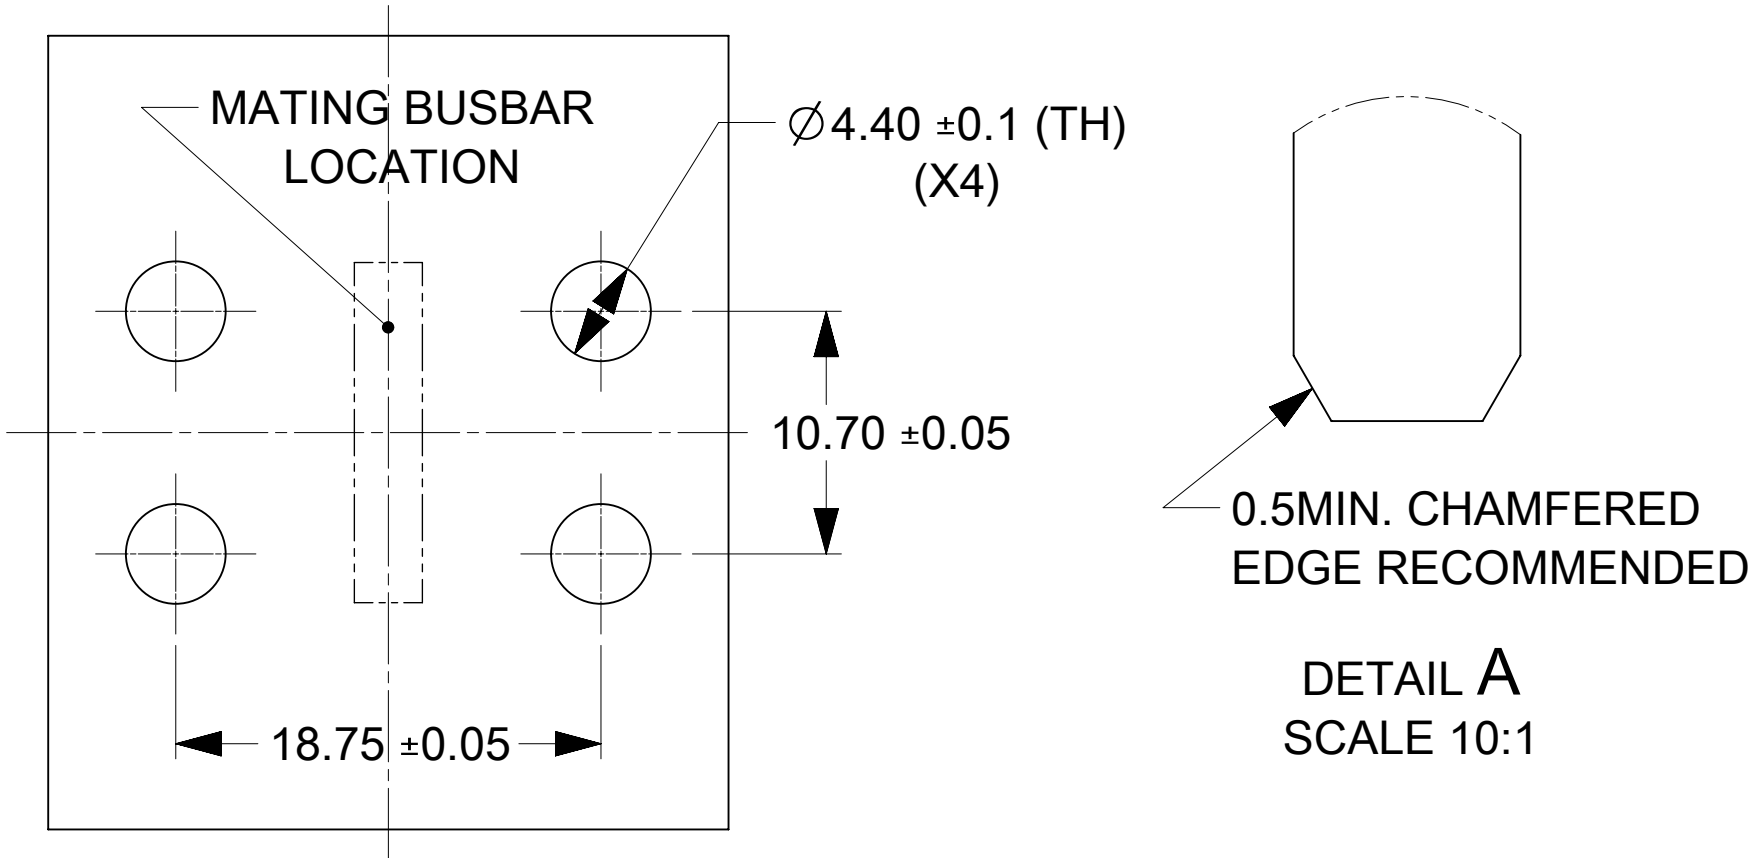


RECOMMENDED BUSBAR LAYOUT

- NOTES:
- MATERIALS:
 - HOUSING BODY: POLYMER, UL94V-0, BLACK.
 - TERMINALS: COPPER ALLOY.
 - RIVET/CLIP: COPPER ALLOY.
 - PLATING:
 - CONTACT AREAS: 3.18 MICRON MIN. SILVER, OVER 1.27 MICRON MIN. NICKEL.
 - TAB AREAS: 3.18 MICRON MIN. TIN OVER 1.27 MICRON MIN. NICKEL.
 - REST: 1.27 MICRON MIN. NICKEL.
 - LUBRICATION: LUBED IN CONTACT AREA.
 - REFERENCE DOCUMENT: 2132740001-PS, 2132740001-AS
 - MODULE ASSEMBLY IS RoHS COMPLIANT.
 - FINAL ASSEMBLY TO BE PACKAGED AND LABELED PER PACKAGING KIT DRAWING NUMBER 2132740003-PK.

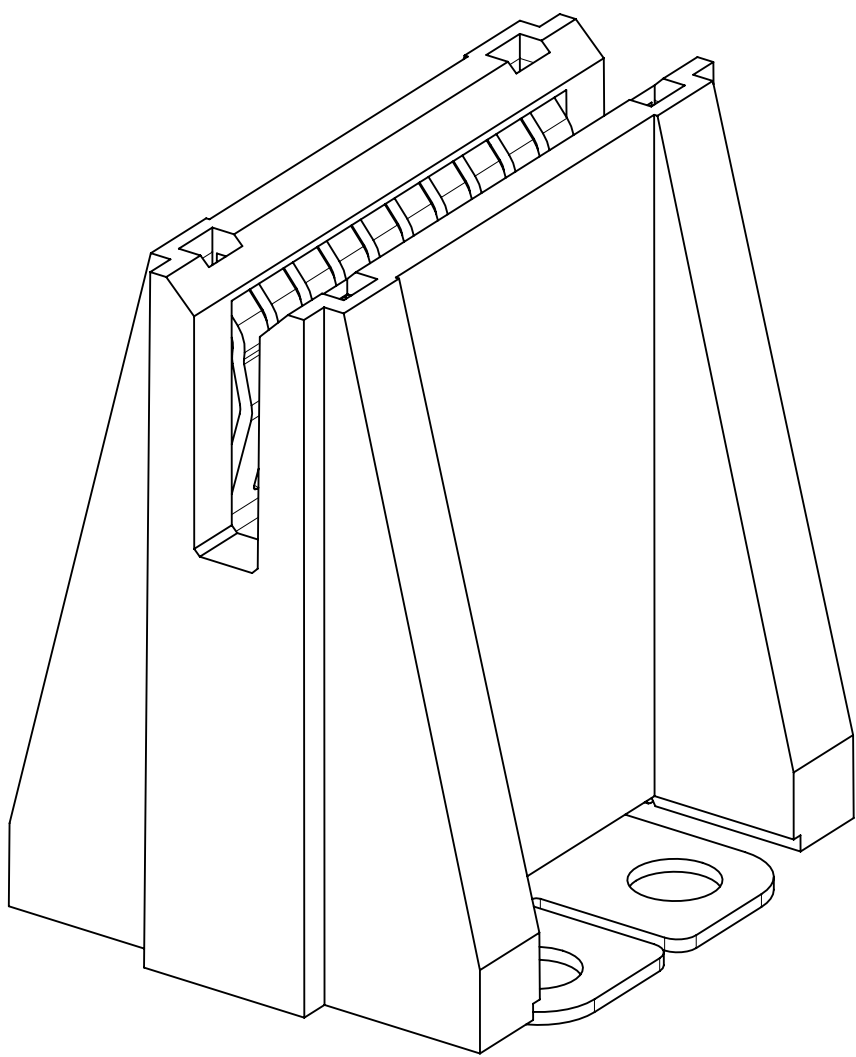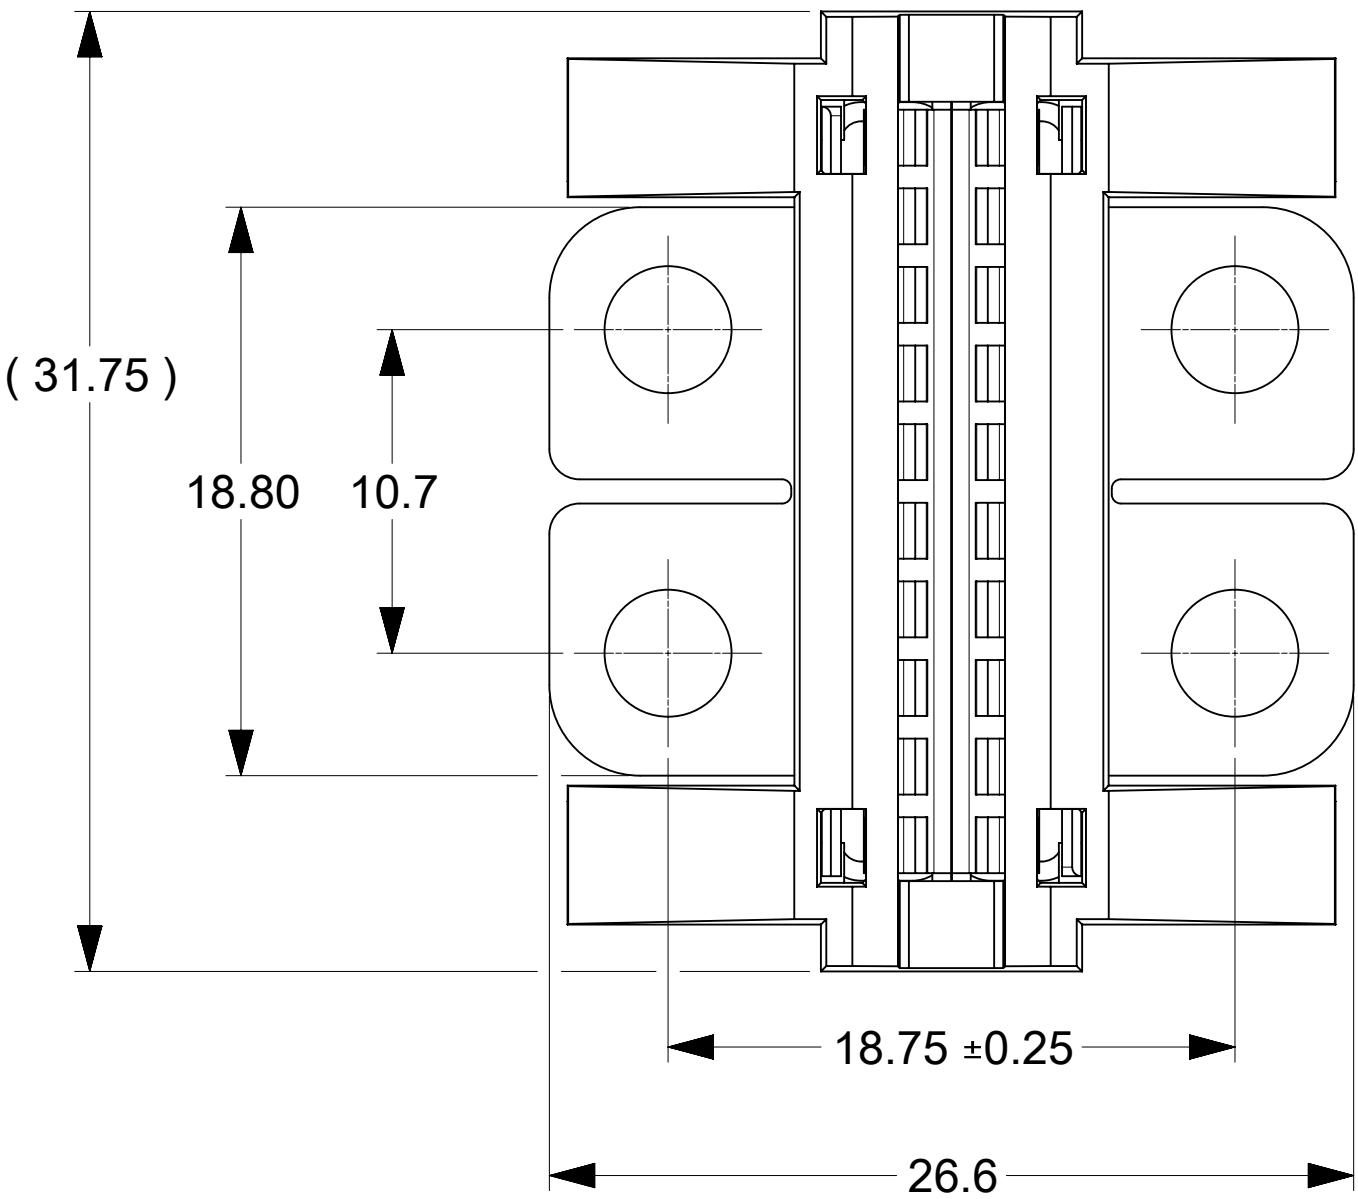

PART NUMBER: 2132740003
(OPEN SIDE WALLS)

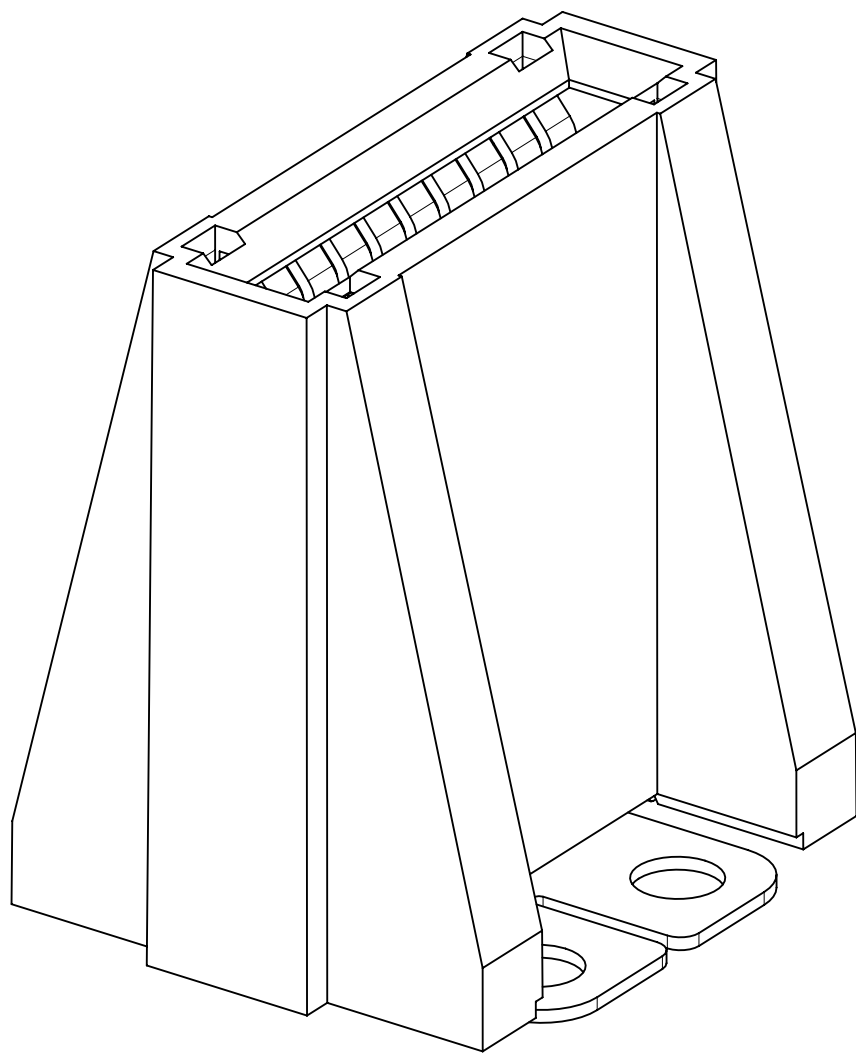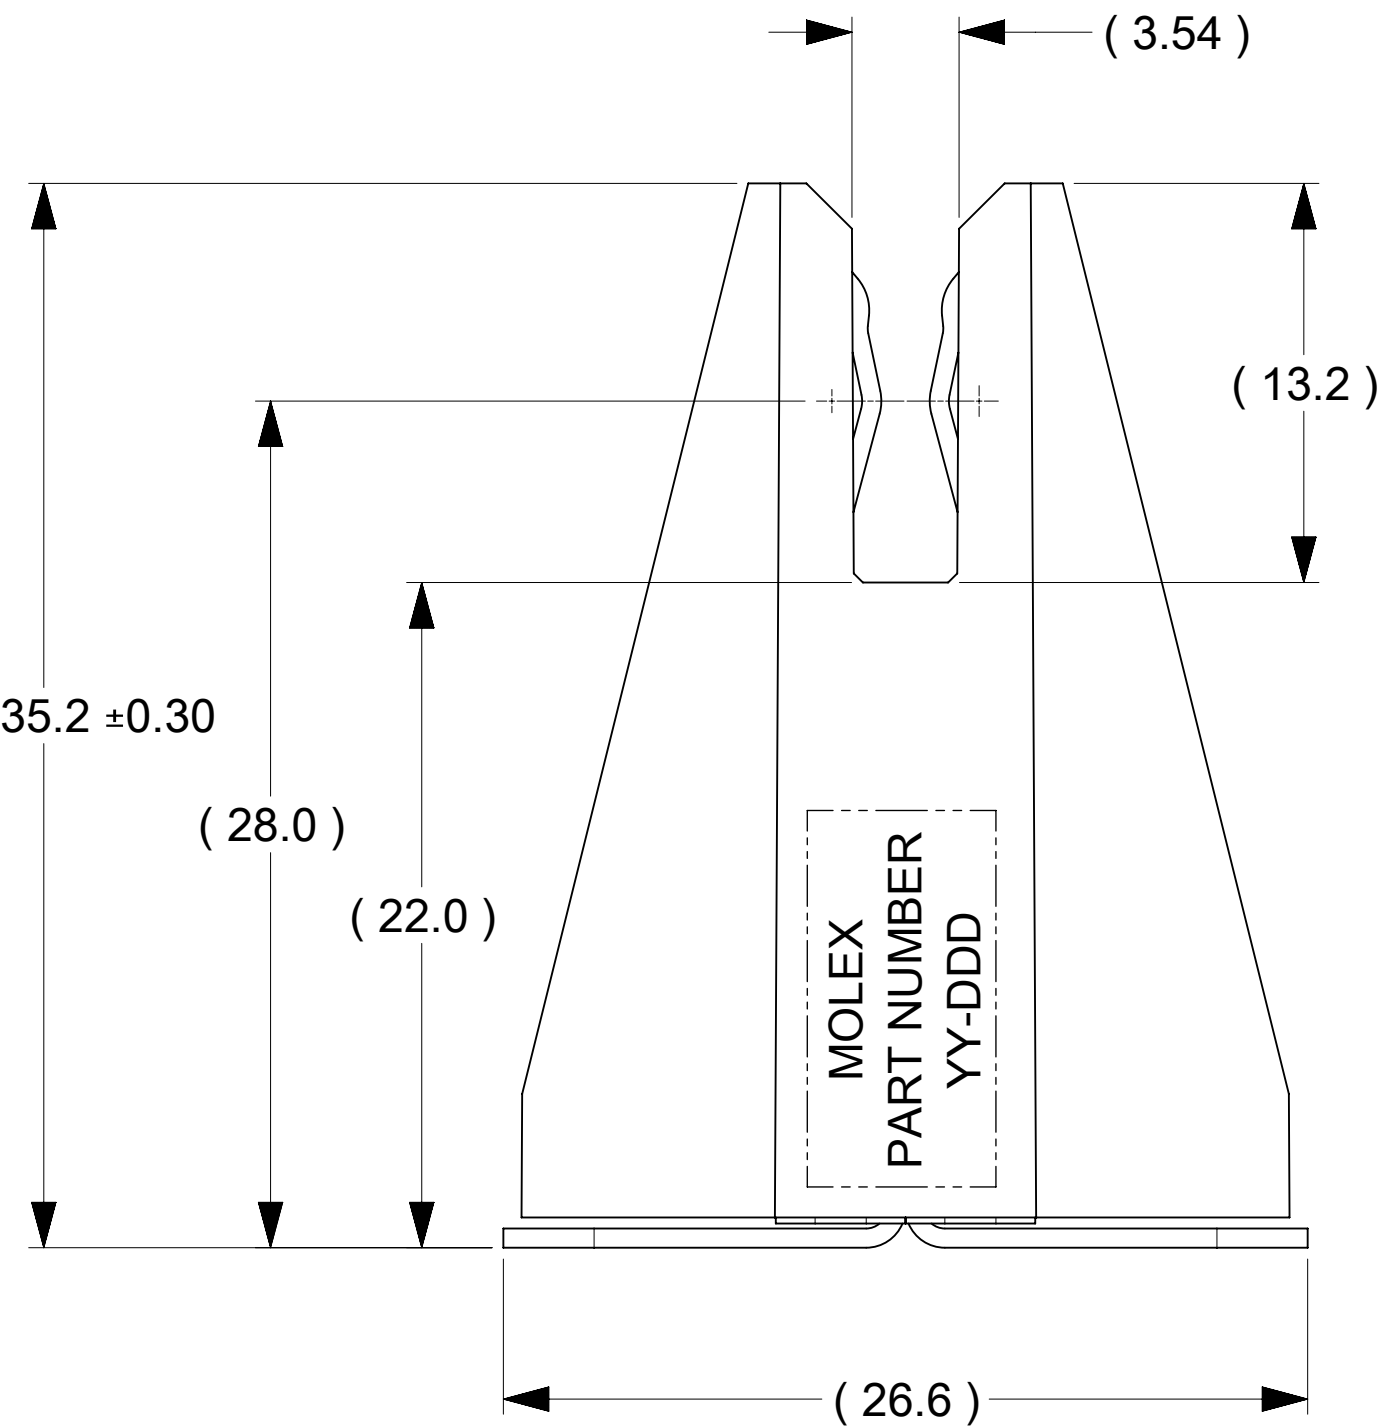

PART NUMBER: 2132741003
(CLOSED SIDE WALLS)

THIS DRAWING CONTAINS INFORMATION THAT IS PROPRIETARY TO MOLEX ELECTRONIC TECHNOLOGIES, LLC AND SHOULD NOT BE USED WITHOUT WRITTEN PERMISSION															
FUNCTIONAL SYMBOLS	DIMENSION UNITS		SCALE		CURRENT REV DESC:				molex						
	mm		3:1												
	DIVISIONAL SYMBOLS	GENERAL TOLERANCES (UNLESS SPECIFIED)				EC NO: 690682 DRWN: TOMLU 2022/01/03 CHK'D: BPISZCZOR 2022/01/04 APPR: BPISZCZOR 2022/01/04 INITIAL REVISION: DRWN: TOMLU 2020/03/02 APPR: BPISZCZOR 2021/12/21				POWER PLANE BBC 10C VERTICAL					
ANGULAR TOL ± °															
4 PLACES		±		PRODUCT CUSTOMER DRAWING											
3 PLACES		±													
2 PLACES		± 0.15													
1 PLACE		± 0.25													
0 PLACES		±		DOCUMENT NUMBER				DOC TYPE		DOC PART		REVISION			
DRAFT WHERE APPLICABLE MUST REMAIN WITHIN DIMENSIONS				THIRD ANGLE PROJECTION		DRAWING		SERIES		MATERIAL NUMBER		CUSTOMER		SHEET NUMBER	
						D-SIZE		213274		2132740003-SD		SEE CHART		PSD 000 A1 1 OF 1	