

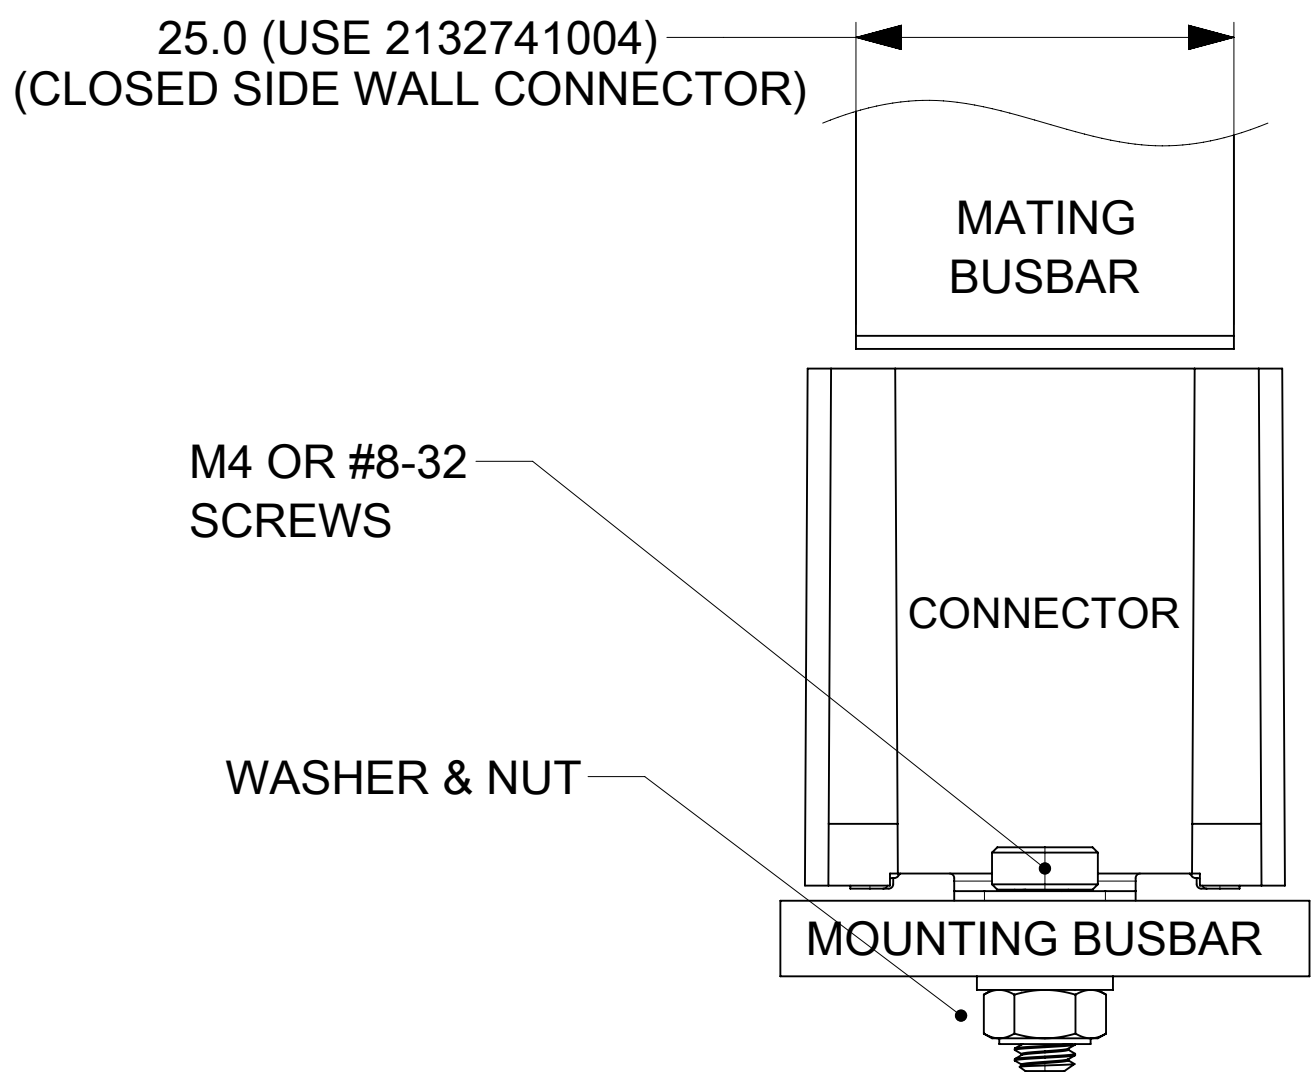
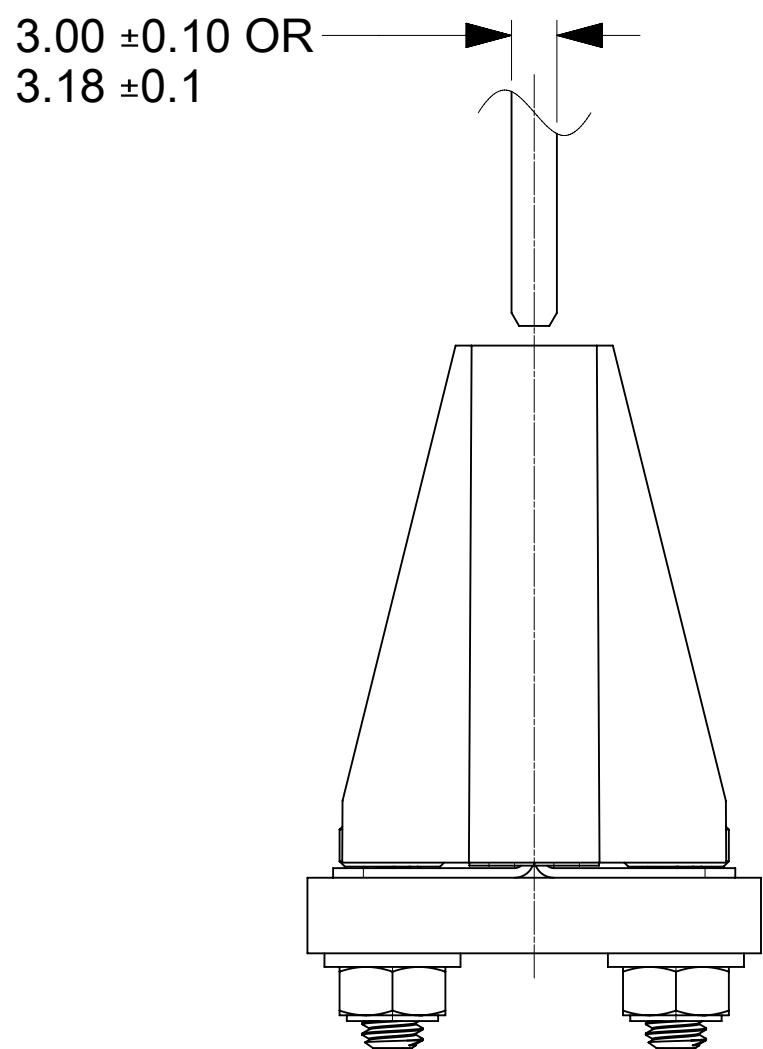
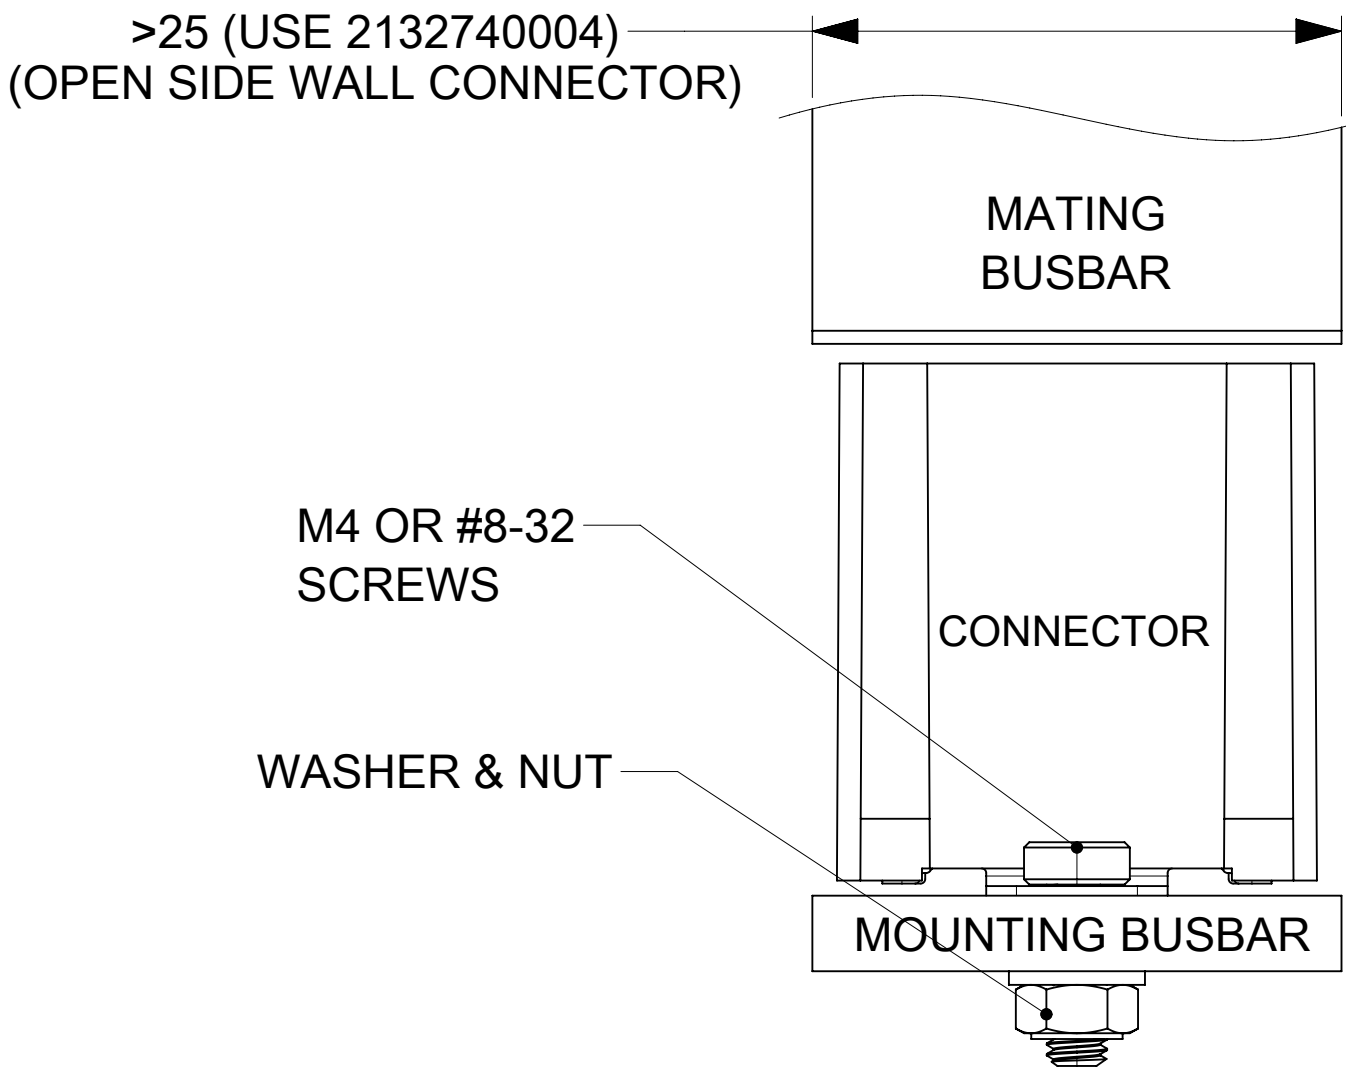
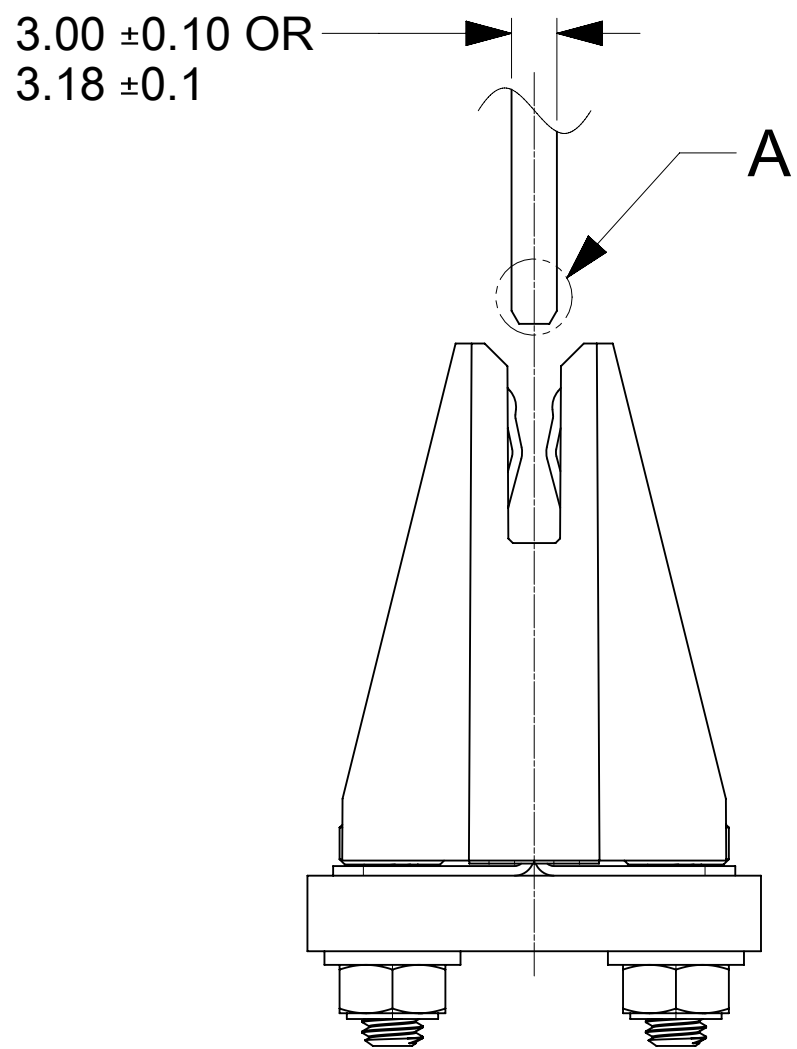





PART NUMBER	DESCRIPTION	NOTE
2132740004	OPEN SIDE WALL	
2132741004	CLOSED SIDE WALL	

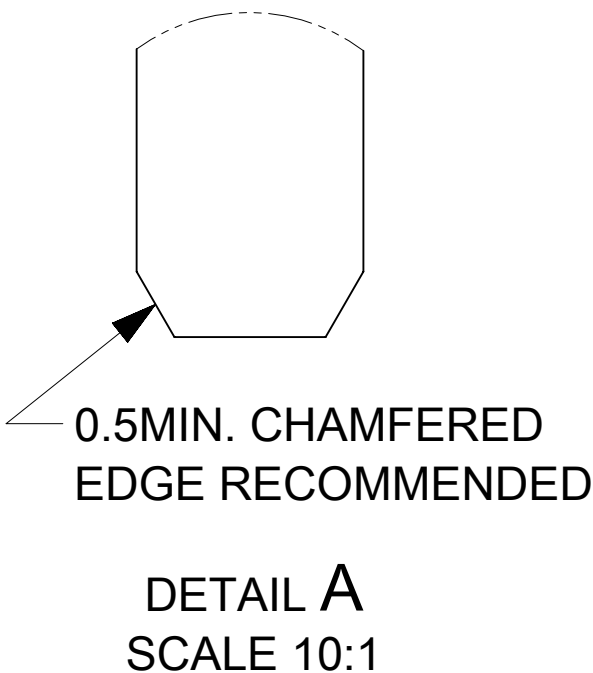


BUSBARS, SCREWS, WASHER AND NUTS
IN THESE VIEWS ARE SHOWN FOR REFERENCE

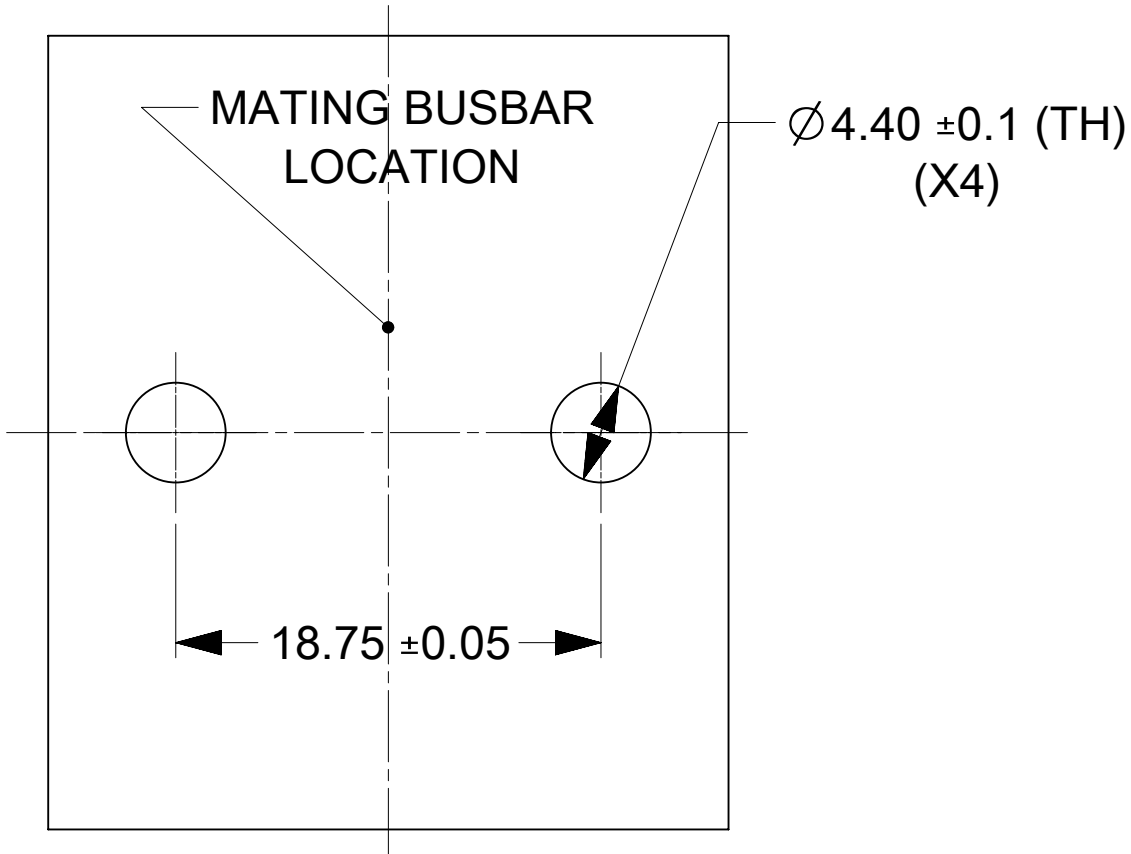

- NOTES:
- MATERIALS:
 - HOUSING BODY: POLYMER, UL94V-0, BLACK.
 - TERMINALS: COPPER ALLOY.
 - RIVET/CLIP: COPPER ALLOY.
 - PLATING:
 - CONTACT AREAS: 3.18 MICRON MIN. SILVER, OVER 1.27 MICRON MIN. NICKEL.
 - TAB AREAS: 3.18 MICRON MIN. TIN OVER 1.27 MICRON MIN. NICKEL.
 - REST: 1.27 MICRON MIN. NICKEL.
 - LUBRICATION: LUBED IN CONTACT AREA.
 - REFERENCE DOCUMENT: 2132740001-PS, 2132740001-AS
 - MODULE ASSEMBLY IS RoHS COMPLIANT.
 - FINAL ASSEMBLY TO BE PACKAGED AND LABELED PER PACKAGING KIT DRAWING NUMBER 2132740003-PK.

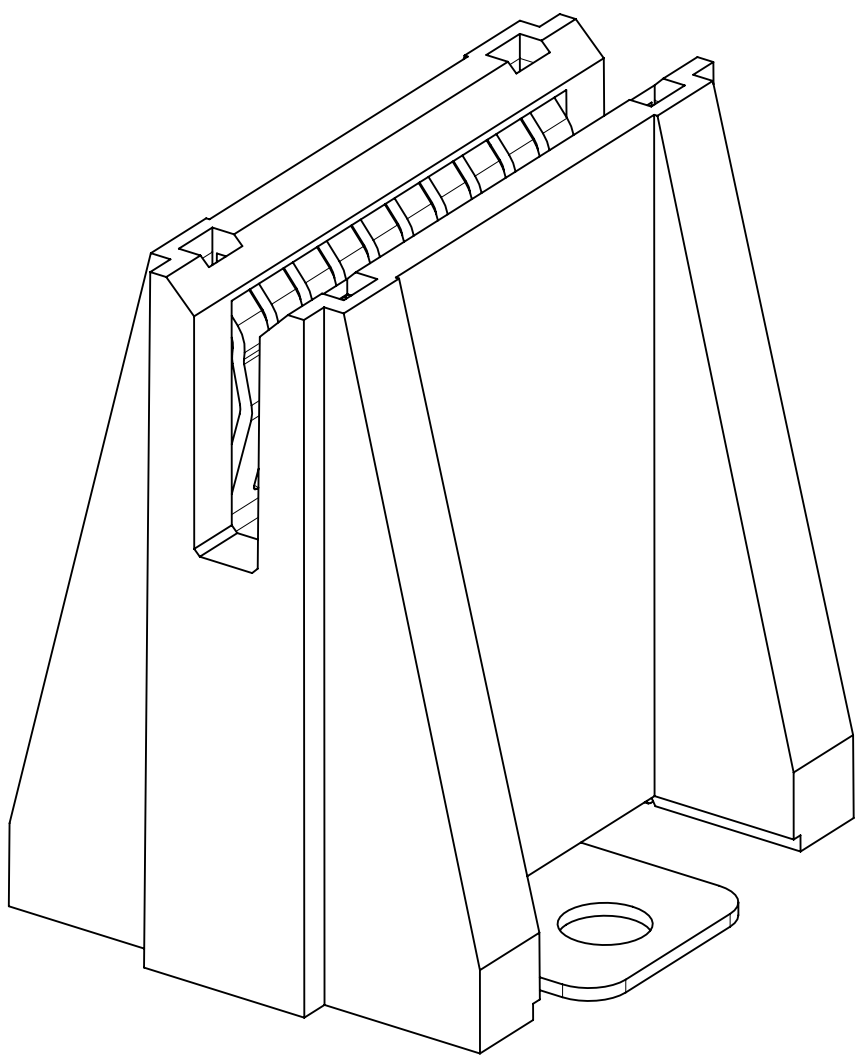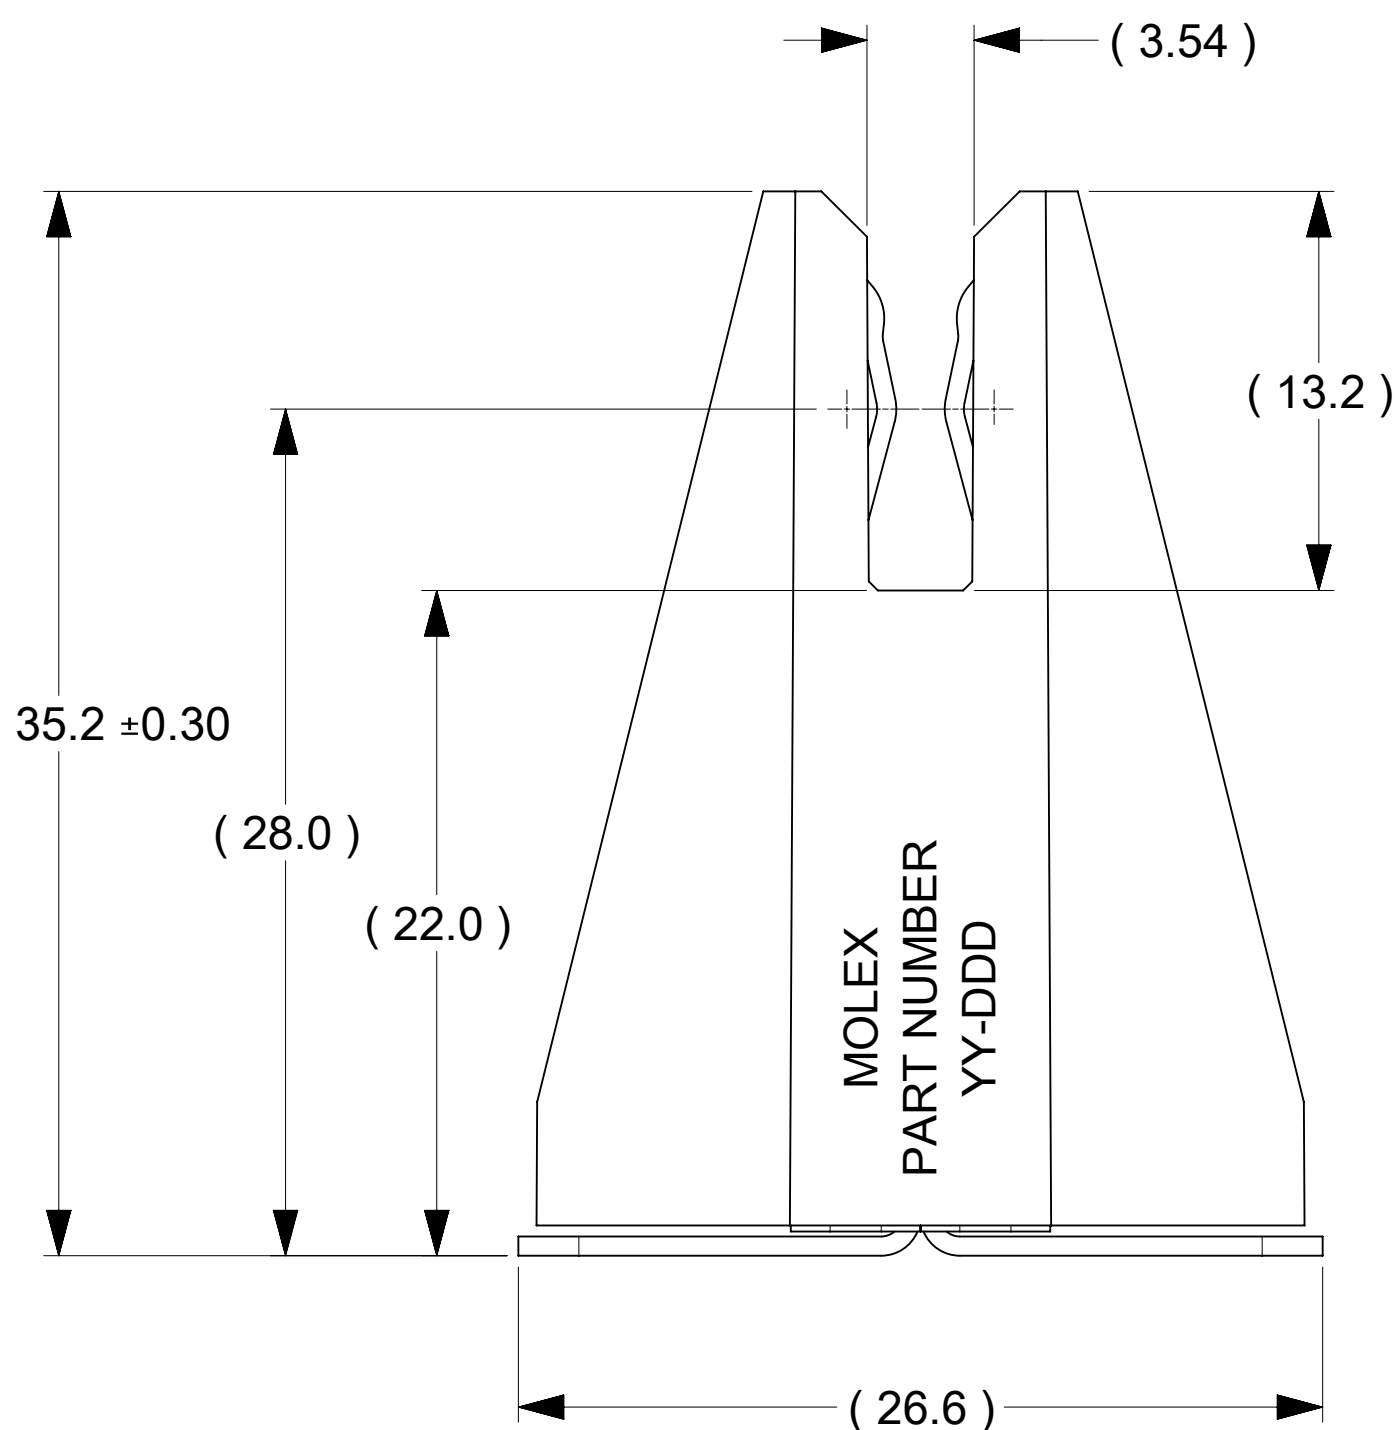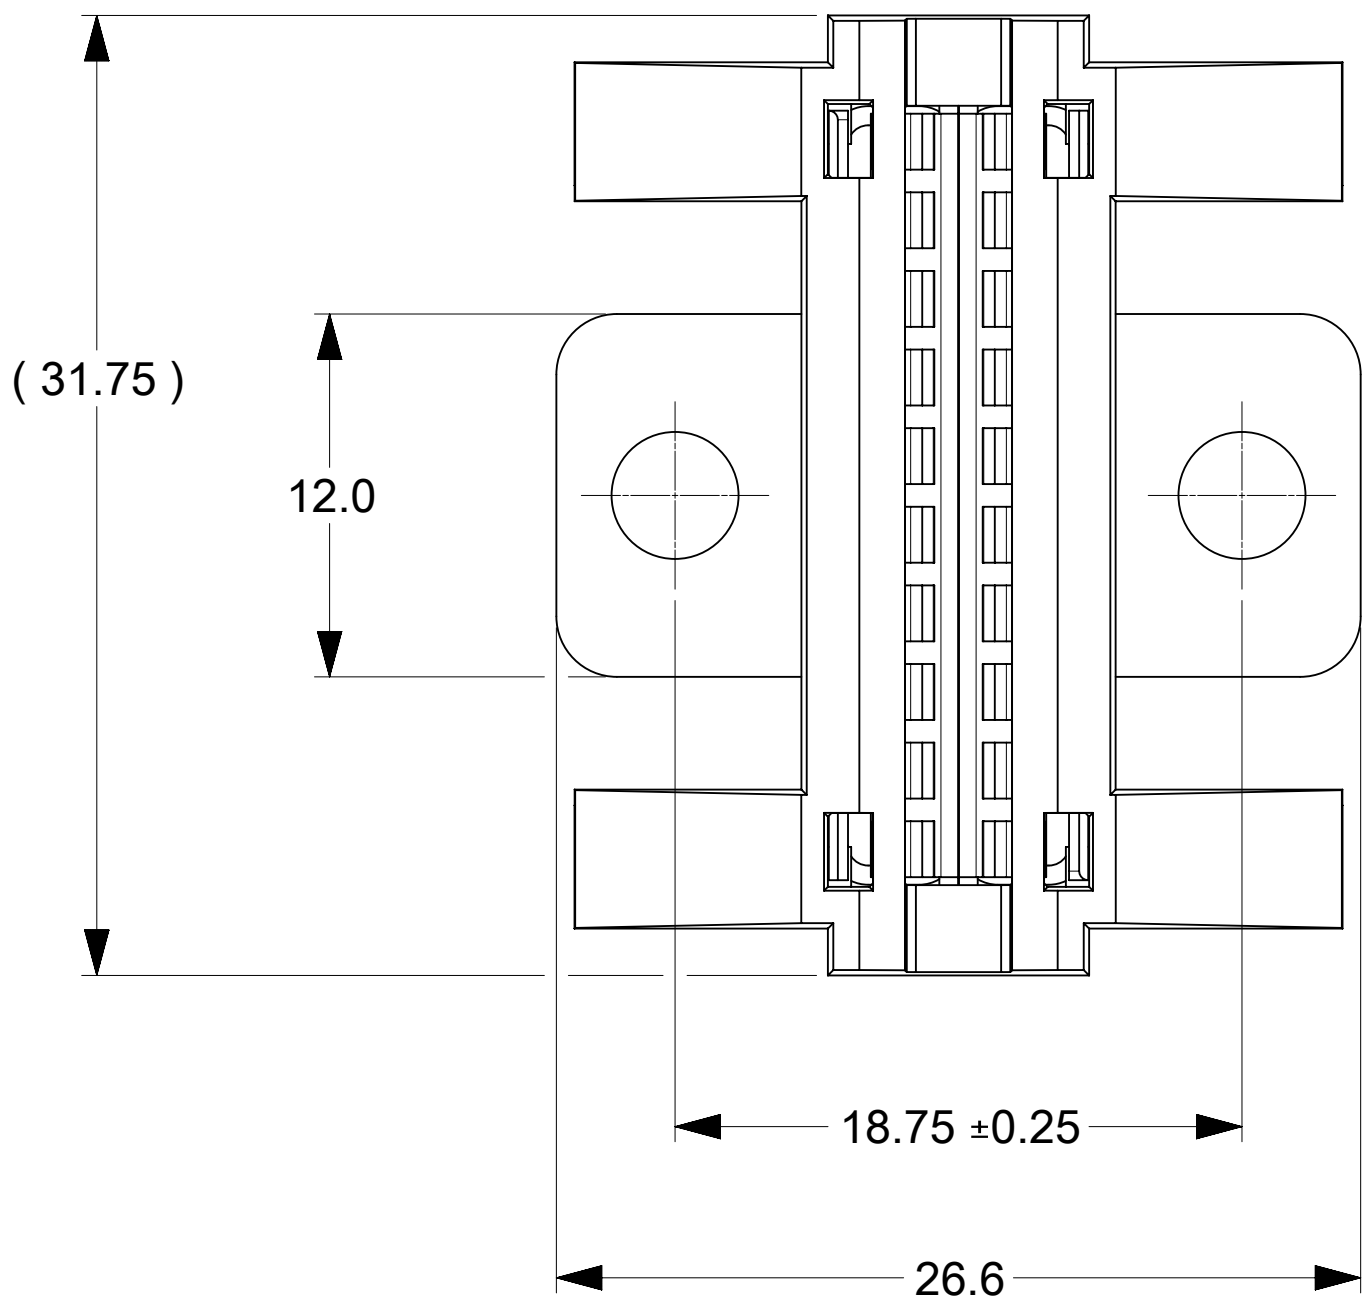

PART NUMBER: 2132740004
(OPEN SIDE WALLS)

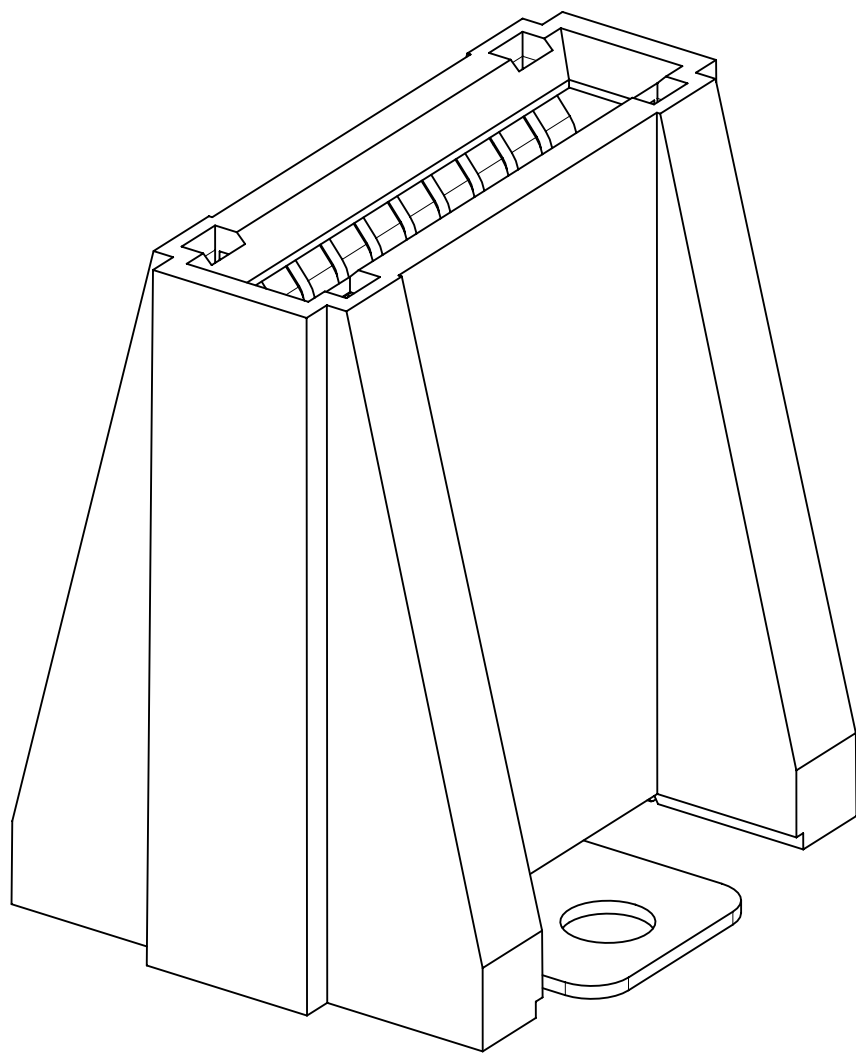

PART NUMBER: 2132741004
(CLOSED SIDE WALLS)

RECOMMENDED BUSBAR LAYOUT

FUNCTIONAL SYMBOLS	THIS DRAWING CONTAINS INFORMATION THAT IS PROPRIETARY TO MOLEX ELECTRONIC TECHNOLOGIES, LLC AND SHOULD NOT BE USED WITHOUT WRITTEN PERMISSION															
A = 0 E = 0 P = 0 DIVISIONAL SYMBOLS	DIMENSION UNITS		SCALE		CURRENT REV DESC:			molex								
	mm		3:1													
	GENERAL TOLERANCES (UNLESS SPECIFIED)					EC NO: 691028 DRWN: TOMLU 2022/03/11 CHK'D: BPISZCZOR 2022/03/22 APPR: BPISZCZOR 2022/03/22			POWER PLANE BBC 10C VERTICAL_SINGLE HOLE							
	ANGULAR TOL ± °															
	4 PLACES		±													
	3 PLACES		±													
	2 PLACES		± 0.15													
	1 PLACE		± 0.25		INITIAL REVISION:			PRODUCT CUSTOMER DRAWING								
0 PLACES		±		DRWN: TOMLU 2021/04/07 APPR: BPISZCZOR 2021/12/21			DOCUMENT NUMBER		DOC TYPE	DOC PART	REVISION					
DRAFT WHERE APPLICABLE MUST REMAIN WITHIN DIMENSIONS					THIRD ANGLE PROJECTION		DRAWING		SERIES		MATERIAL NUMBER		CUSTOMER		SHEET NUMBER	
							D-SIZE		213274		SEE CHART				1 OF 1	

DOCUMENT STATUS	P1	RELEASE DATE	2022/03/22	03:56:37
-----------------	----	--------------	------------	----------